
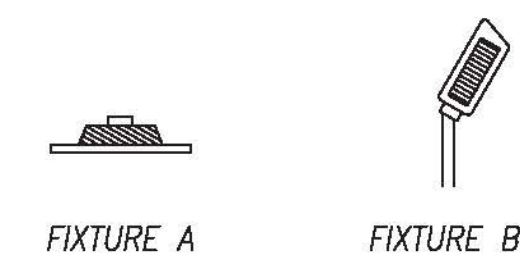


LUMINAIRE SCHEDULE						
FIXTURE	SYMBOL	QTY	LABEL	ARRANGEMENT	LUMENS	LLF
A		17	P1	SINGLE	695	.880
B		4	P2	SINGLE	500	.880
					DESCRIPTION	
					HLBSL-4 (HALO)	
					HLS16-LM (TELLURIDE)	

CALCULATION SUMMARY							
LABEL	CALC TYPE	UNITS	AVG	MAX	MIN	AVG/MIN	MAX/MIN
SITE FLOOR	ILLUMINANCE	Fc	2.03	114	0.0	N.A.	N.A.

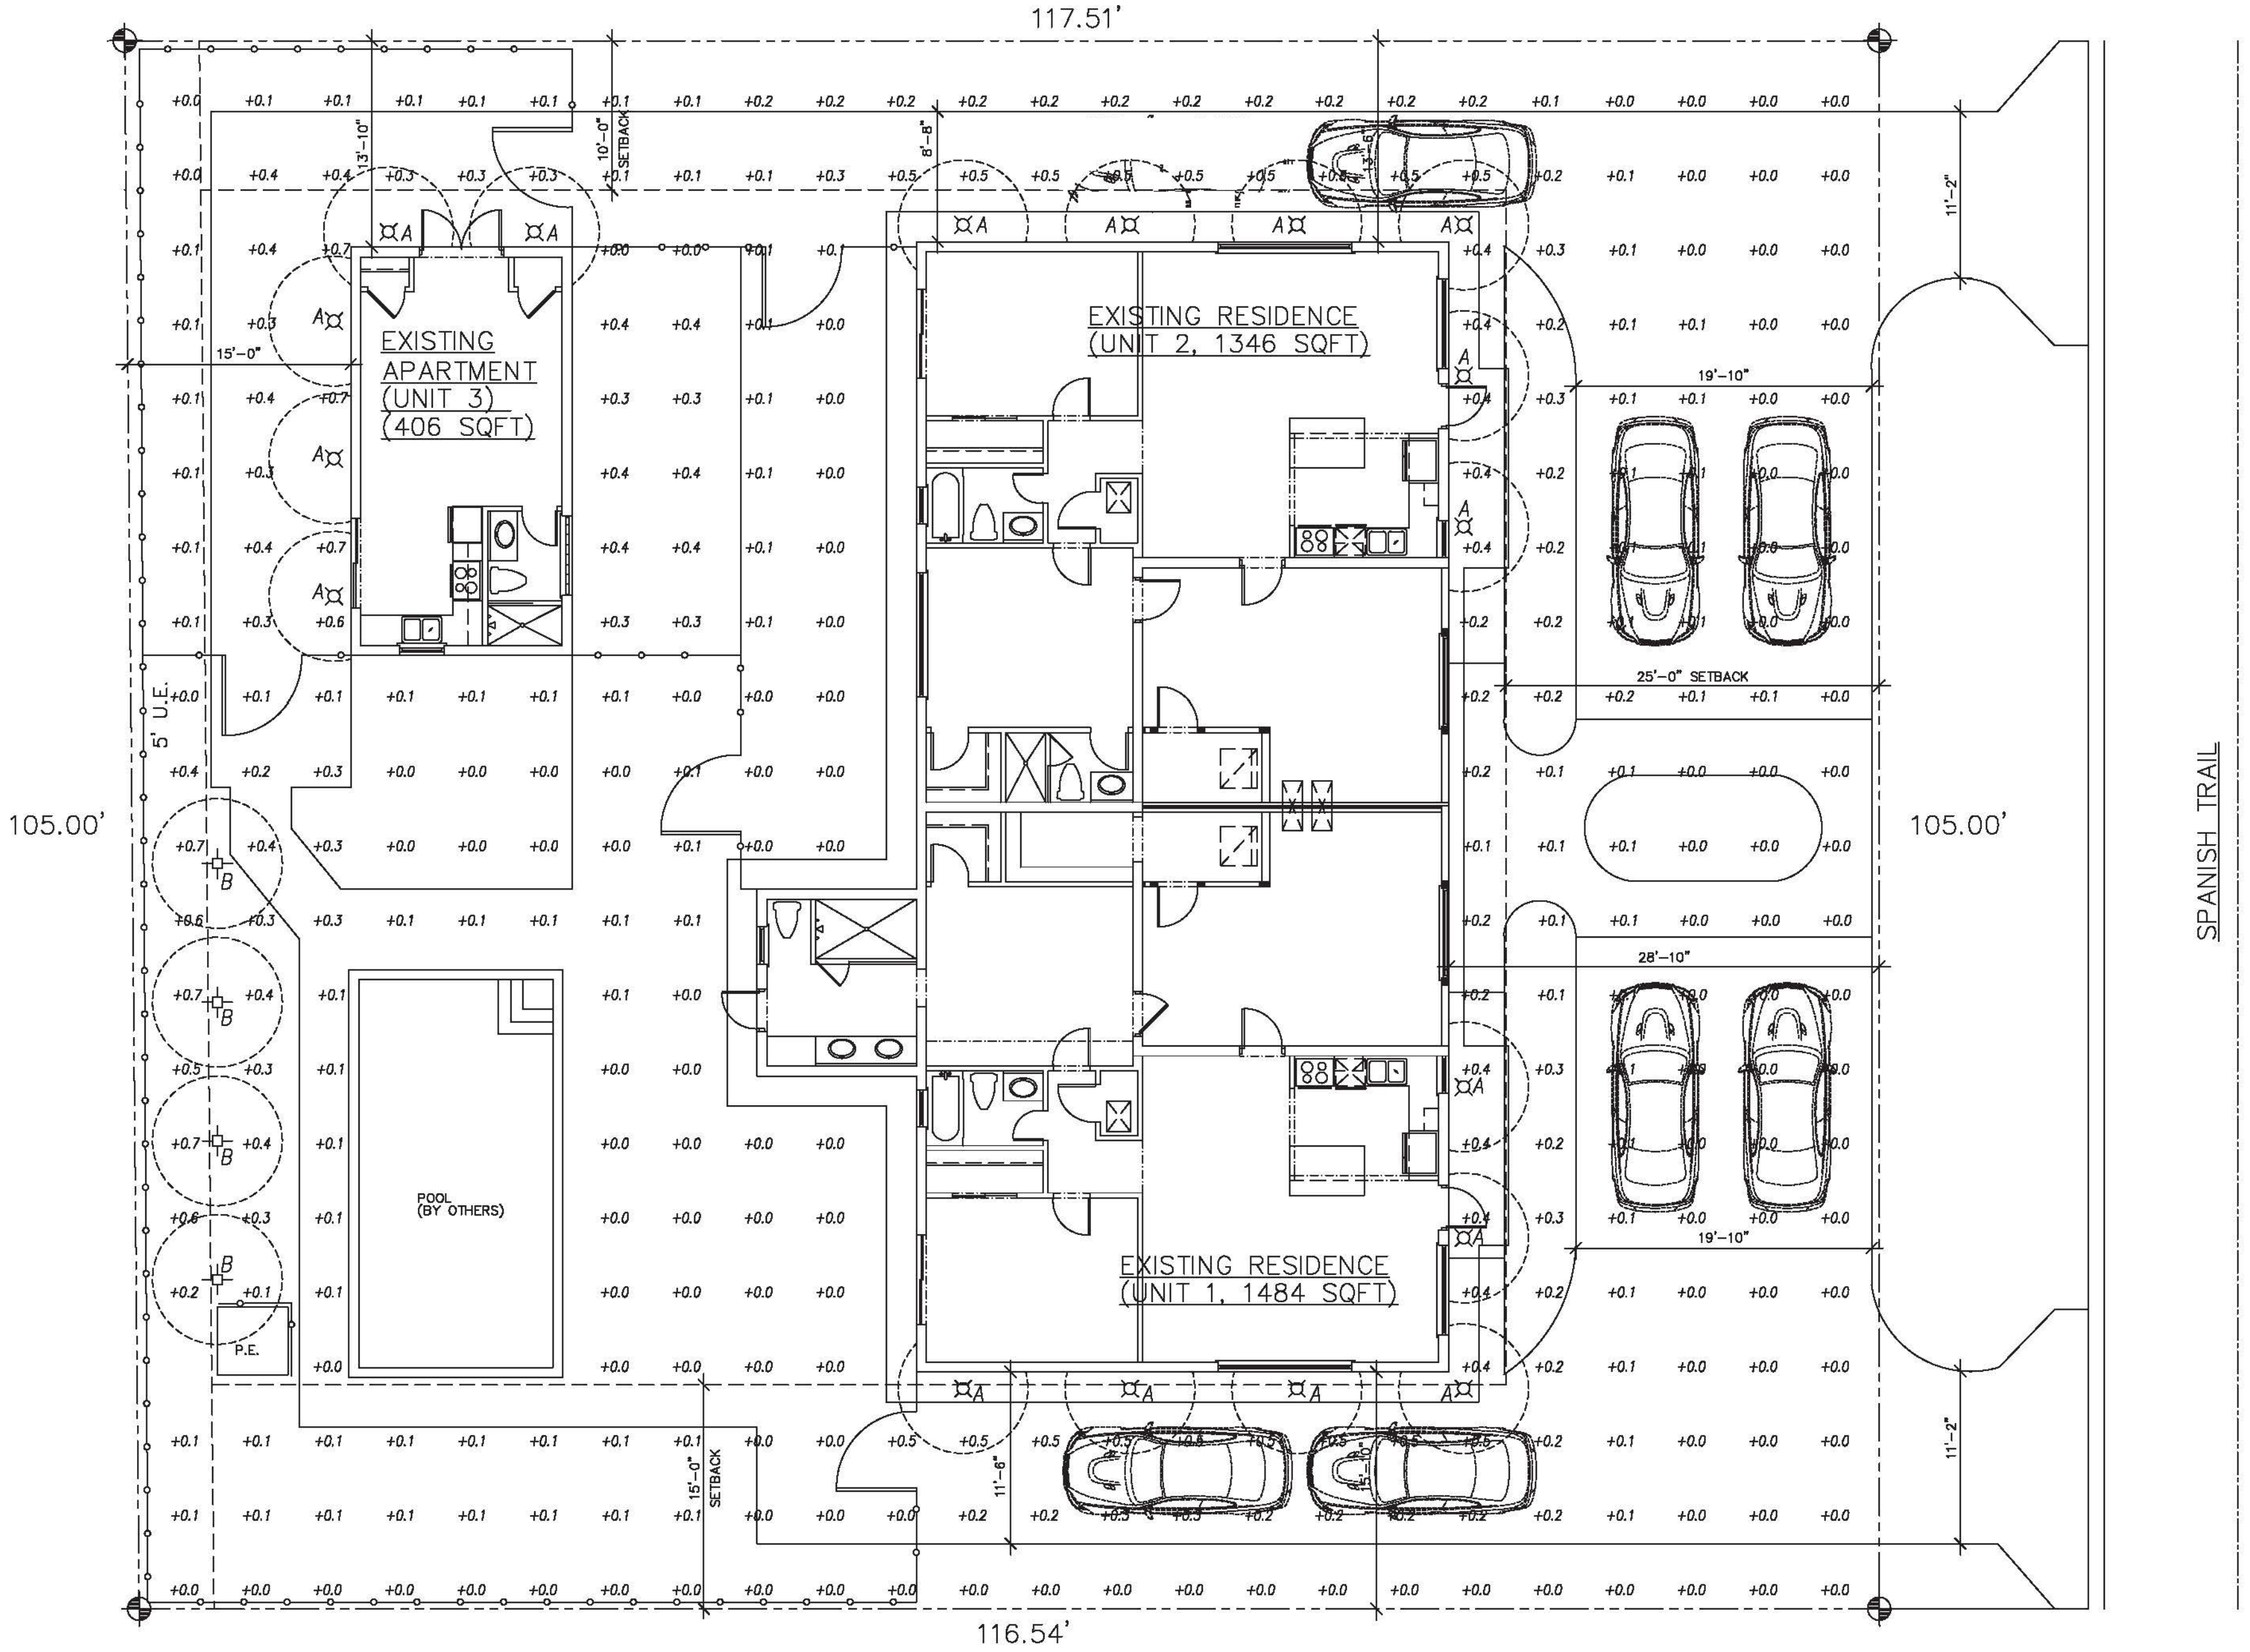

PHOTOMETRIC SITE PLAN

SCALE: 1/8" = 1'-0"

Signed by:

12/9/2024

RENOVATION at: 2312 Spanish Trail, Delray Beach, FL			
For: SPANISH RIVER ROAD APARTMENTS			
PHOTOMETRIC SITE PLAN			
plan #: 0000	McCARRON / ASSOC., Inc.		sheet #: 4
job #: 24F810	A.I.B.D. - F.R.D.A.		
date: 12/05/24	638 EDDY ST., BOCA RATON, FL 33487 561-997-0579 mccarronassoc@att.net	561-350-4364 www.mccarroninc.com	of: 4