

 COMMERCIAL OUTDOOR One Lithonia Way • Conyers, Georgia 30012 • Phone: 1-800-705-SERV (7378) • www.lithonia.com RA08-LE
© 2012-2014 Acuity Brands Lighting, Inc. All rights reserved. Rev. 8/27/12

 **LITHONIA
LIGHTING** COMMERCIAL OUTDOOR One Lithonia Way • Conyers, Georgia 30012 • Phone: 1-800-705-SERV (7378) • www.lithonia.com RADPT LED
© 2011-2024 Acuity Brands Lighting, Inc. All rights reserved. Res. 11/14/24

 **COMMERCIAL OUTDOOR** One Lithonia Way • Conyers, Georgia 30012 • Phone: 1-800-705-SERV (7378) • www.lithonia.com RADPT LED
© 2011, 2014 Acuity Brands Lighting, Inc. All rights reserved. Rev. 11/14/24

Revision	Date	Description
△	09-19-25	SPRAB COMMENT
△	12-19-25	SPRAB COMMENT
△	03-16-26	SPRAB COMMENT
△	05-20-26	SPRAB COMMENT
△		
△		
△		

2419 N. FEDERAL HWY PHOTOMETRIC PLAN

FLORIDA 33483

DELRAY BEACH

TYECO

THOMPSON & YOUNGROSS
ENGINEERING CONSULTANTS, LLC

C.O.A. NO. 25996

HVAC
PLUMBING
ELECTRICAL
FIRE ALARM
& SPRINKLER

ANDREW J. YOUNGROSS
LICENSE
NO. 9798
STATE OF
FLORIDA
PROFESSIONAL ENGINEER

902 CLINT MOORE ROAD
SUITE 142
BOCA RATON, FLORIDA 33487

O: 561-274-0200
F: 561-274-0222
E: tec@tecfila.com
www.tecfila.com

THESE DRAWINGS ARE PREPARED PER ESTABLISHED INDUSTRY STANDARDS AND REPRESENT THE ENGINEERS DESIGN CONCEPT. THEY ARE NOT INTENDED TO PROVIDE CONTRACTORS OR SUBMITTALS REQUIRED TO CONSTRUCT THE BUILDING. THE CONTRACTOR THROUGH SUBMITTALS AND OTHER COORDINATION EFFORTS IS FULLY RESPONSIBLE FOR PROVIDING A COMPLETE AND OPERATIONAL BUILDING, WHETHER INDICATED ON THE PLANS OR NOT.

Job Number

Issued for:

Permit

25056

05-25-25

Design By:

Drawn By:

Checked By:

Scale :


AJY

AJY

AJY

AS NOTED

ES0.1

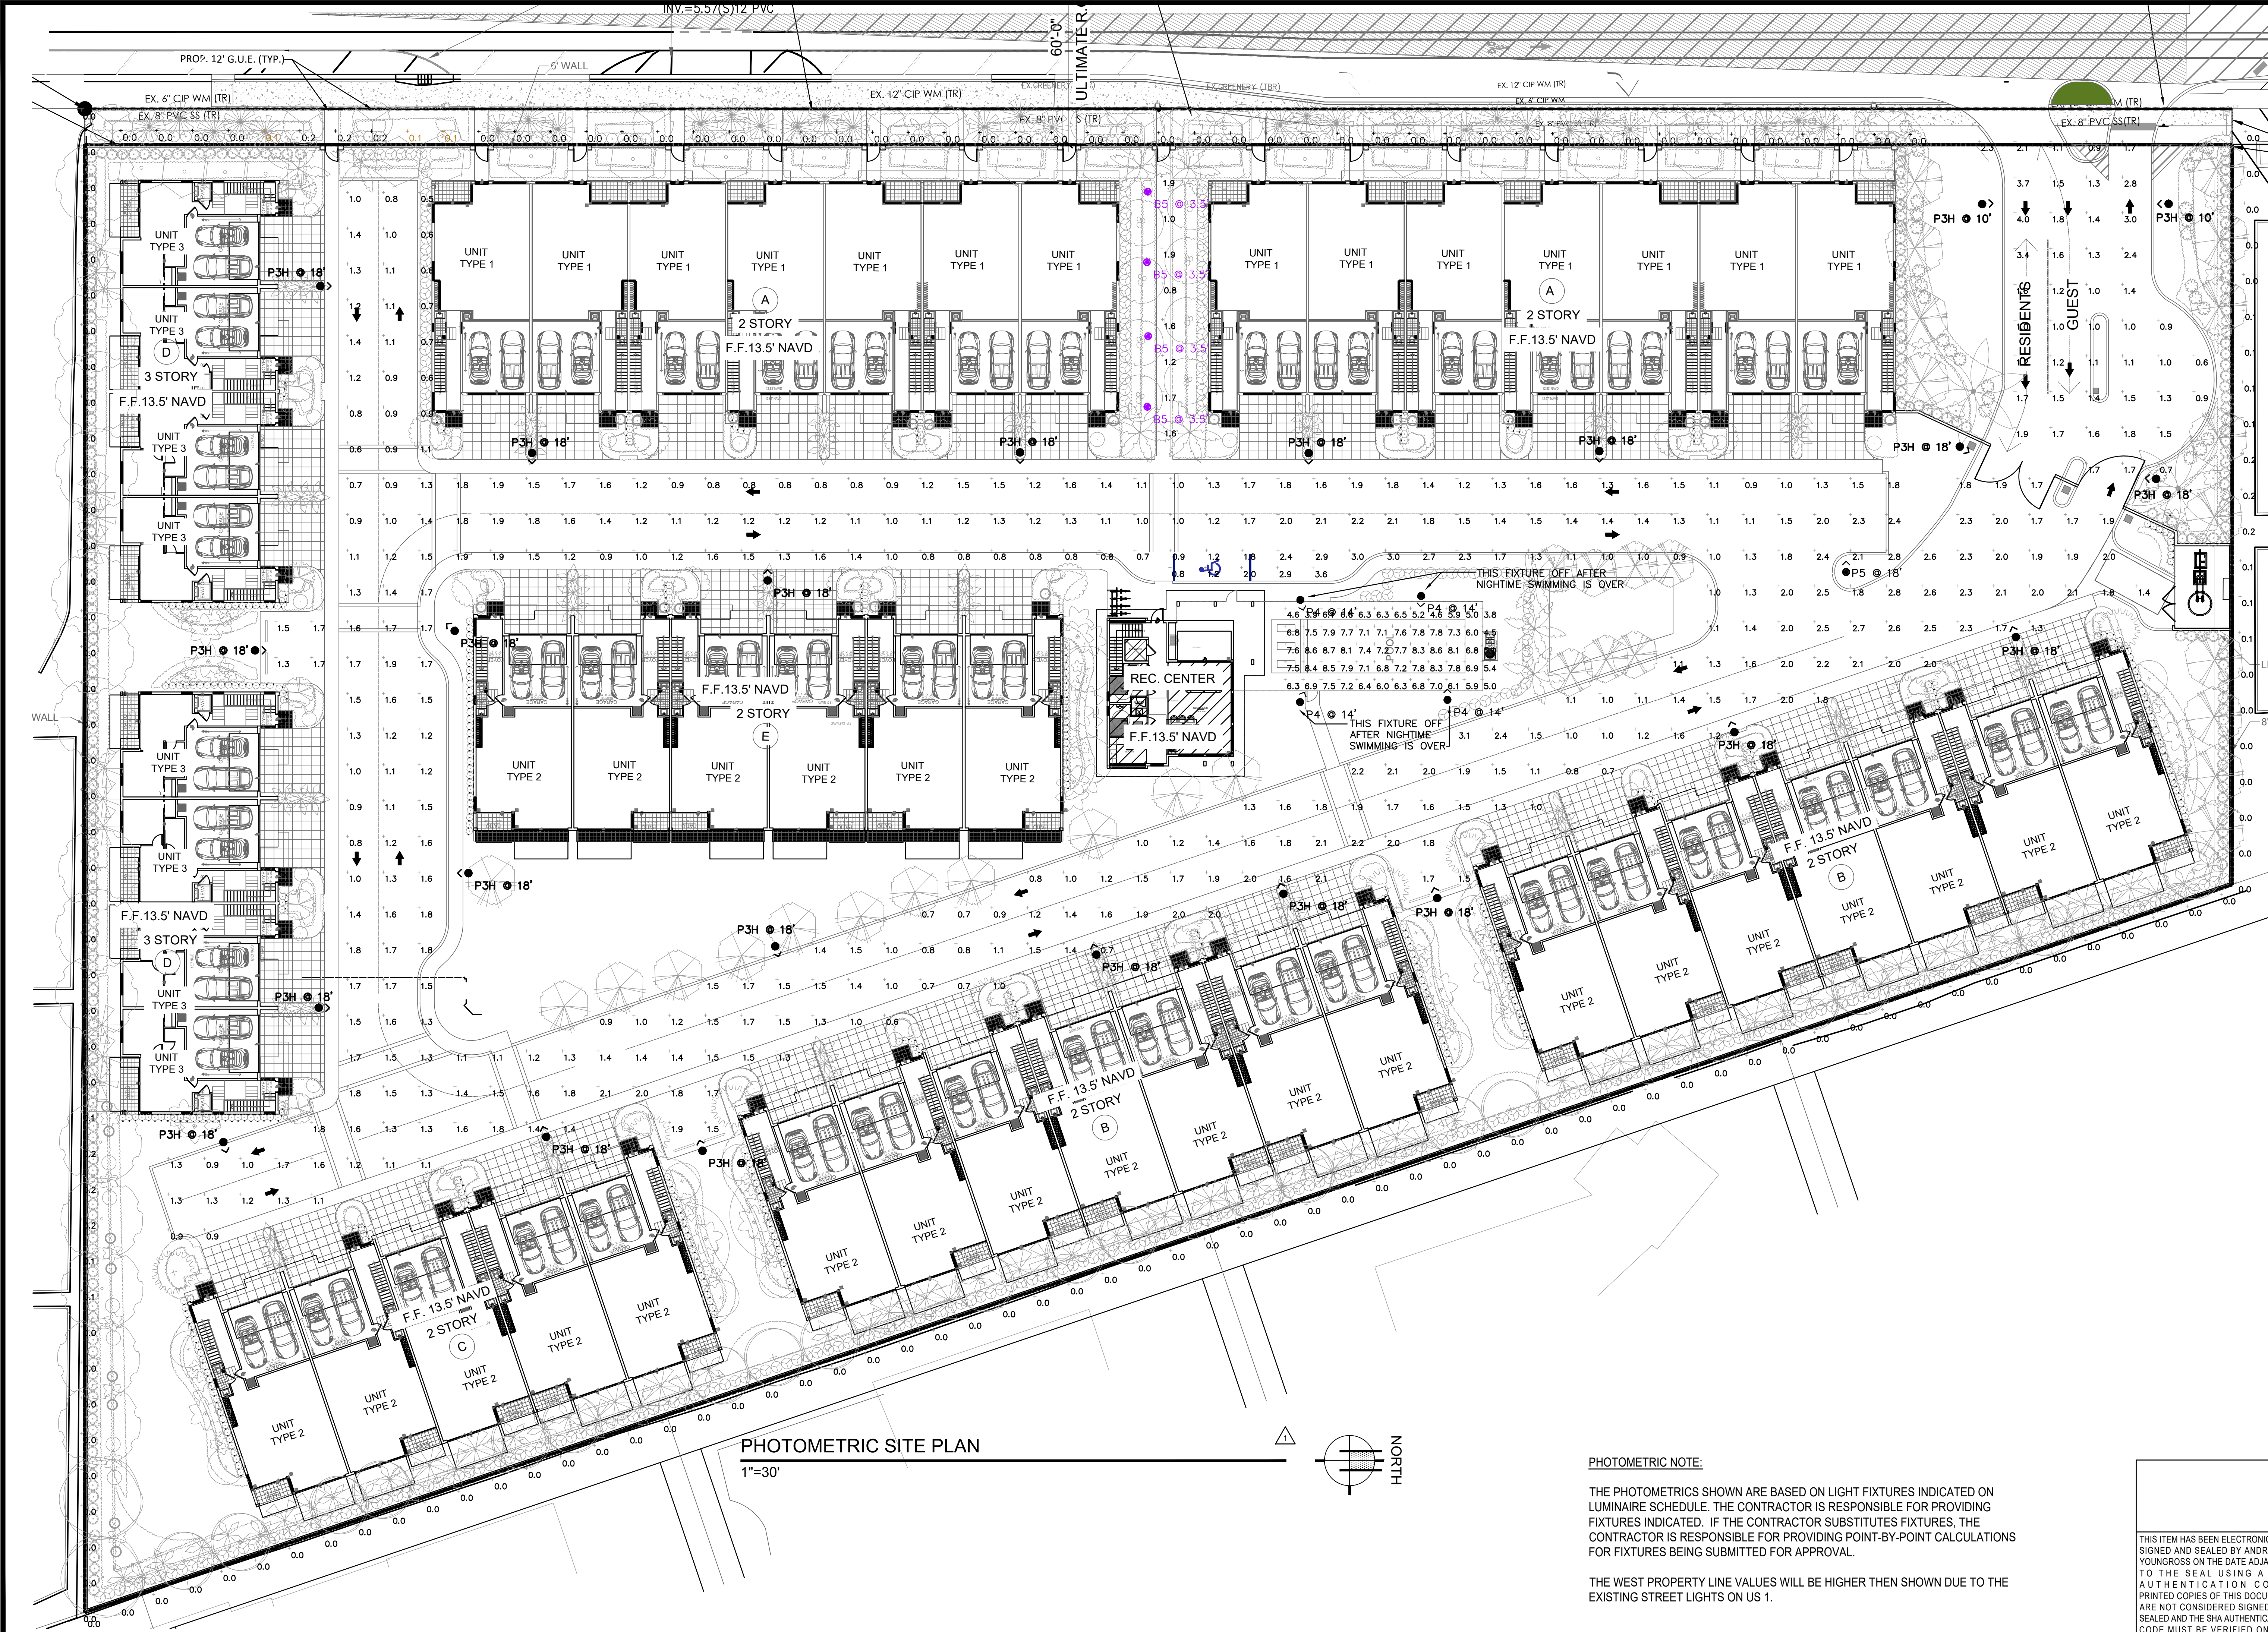

2419 N. FEDERAL HWY
PHOTOMETRIC PLAN

TYEC
THOMPSON & YOUNGROSS
ENGINEERING CONSULTANTS, LLC
C.O.A. NO. 25996

ANDREW J. YOUNGROSS
LICENSE
NO. 5758
STATE OF
FLORIDA
PROFESSIONAL ENGINEER

902 CLINT MOORE ROAD
SUITE 142
BOCA RATON, FLORIDA 33487
O: 561-274-0200
F: 561-274-0222
E: tec@tecfla.com
www.tecfla.com

THESE DRAWINGS ARE PREPARED PER ESTABLISHED INDUSTRY STANDARDS AND REPRESENT THE ENGINEER'S DESIGN CONCEPT. THEY ARE NOT INTENDED TO PROVIDE EVERY DETAIL OR CONDITION FOR CONSTRUCTION. THE CONTRACTOR SHALL BE RESPONSIBLE FOR PROVIDING A COMPLETE AND OPERATIONAL BUILDING WHETHER INDICATED ON THE PLANS OR NOT.

Job Number 25056
Issued for:
Permit 05-25-25

Design By: AJY
Drawn By: AJY
Checked By: AJY
Scale: AS NOTED

THIS ITEM HAS BEEN ELECTRONICALLY SIGNED AND SEALED BY ANDREW J. YOUNGROSS ON THE DATE ADJACENT TO THE SEAL USING A SHA AUTHENTICATION CODE. PRINTED COPIES OF THIS DOCUMENT ARE NOT CONSIDERED SIGNED AND SEALED AND THE SHA AUTHENTICATION CODE MUST BE VERIFIED ON ANY ELECTRONIC COPIES.

ES1.1

PHOTOMETRIC NOTE:

THE PHOTOMETRICS SHOWN ARE BASED ON LIGHT FIXTURES INDICATED ON LUMINAIRE SCHEDULE. THE CONTRACTOR IS RESPONSIBLE FOR PROVIDING FIXTURES INDICATED. IF THE CONTRACTOR SUBSTITUTES FIXTURES, THE CONTRACTOR IS RESPONSIBLE FOR PROVIDING POINT-BY-POINT CALCULATIONS FOR FIXTURES BEING SUBMITTED FOR APPROVAL.

THE WEST PROPERTY LINE VALUES WILL BE HIGHER THEN SHOWN DUE TO THE EXISTING STREET LIGHTS ON US 1.