



CARVER ISLE


DELRAY BEACH, FL

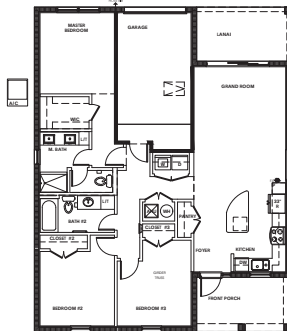

MODEL A - FLOOR PLAN

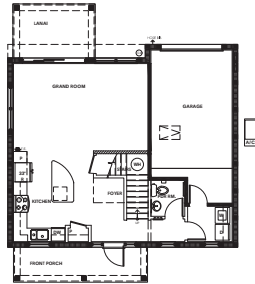

MODEL B - FIRST FLOOR PLAN

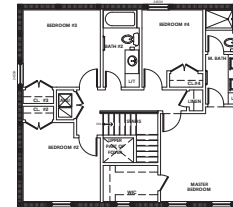

MODEL B - SECOND FLOOR PLAN



MODEL A - ELEVATION 1



MODEL B - ELEVATION 1



MODEL A - ELEVATION 2



MODEL B - ELEVATION 2



MODEL A - ELEVATION 3



MODEL B - ELEVATION 3

DRAWING INDEX

A-0.0	COVER SHEET - MODEL A & B
A-1.0	PROPOSED SITE PLAN - MODEL A & B
A-1.1	PROPOSED LOT PLANS - MODEL A OR B
A-2.0	FOUNDATION, COLUMN & BEAM PLAN - MODEL A & B
A-3.0	FLOOR PLAN, KEYNOTES & WALL LEGEND - MODEL A OR B
A-3.1	FLOOR PLAN - WINDOW & DOOR SCHED. - MODEL A OR B
A-4.1	ROOF PLAN - MODEL A1 OR B1
A-4.2	ROOF PLAN - MODEL A2 OR B2
A-4.3	ROOF PLAN - MODEL A3 OR B3
A-5.1	EXTERIOR ELEVATIONS & KEYNOTES - MODEL A1 OR B1
A-5.2	EXTERIOR ELEVATIONS & KEYNOTES - MODEL A2 OR B2
A-5.3	EXTERIOR ELEVATIONS & KEYNOTES - MODEL A3 OR B3
A-6.0	WINDOW & DOOR DETAILS - MODEL A & B
A-6.1	WINDOW & DOOR DETAILS - MODEL A & B
A-6.2.0	ROOF DETAILS - MODEL A & B
A-6.2.1	DETAILS - MODEL A & B
A-6.2.2	FIRE RATED ASSEMBLIES - MODEL A & B
A-6.2.3	FIRE RATED ASSEMBLIES - MODEL A & B
A-6.2.4	FIRE RATED ASSEMBLIES - MODEL A & B
A-6.2.5	FIRE RATED ASSEMBLIES - MODEL A & B
A-7.0	INTERIOR ELEVATIONS - MODEL A & B
M-1	HVAC PLANS - MODEL A & B
E-1	ELECTRICAL PLANS - MODEL A & B

APPLICABLE CODES

DESCRIPTION OF PROJECT

PROFESSIONALS

OWNER:

ARCHITECT:
PASQUALE KURITZKY ARCHITECTURE, INC.
5101 N.W. 21ST AVENUE, SUITE 360
FORT LAUDERDALE, FL 33309
PH: (954) 332-0184
FAX: (954) 332-0187

STRUCTURE:

MEP ENGINEER:



5101 N.W. 21ST AVENUE, SUITE 360
FORT LAUDERDALE, FL 33309
T: (954) 332-0184
F: (954) 332-0187
AA0002517

COPYRIGHT © 2018
PASQUALE KURITZKY ARCHITECTURE, INC.
ALL RIGHTS RESERVED. THIS DOCUMENT OR PARTS
HEREOF MAY NOT BE REPRODUCED IN ANY FORM
WITHOUT PERMISSION.

DESIGNED - JP

DRAWN - PKA

CHECKED - JP

☐ JOSEPH JOHN PASQUALE, JR.
ARCHITECT
☐ HANAN L. KURITZKY
ARCHITECT

CITY OF DELRAY CRA
CARVER ISLE

DELRAY BEACH, FLORIDA

PROJECT NO. 1807

DATE: 11-01-18

REVISIONS

COVER

A-0.0
DESIGN DEVELOPMENT

DESIGNED JP

DRAWN PKA

CHECKED JP

☐ JOSEPH JOHN PASQUALE, JR.
ARCHITECT
☐ HANNAH L. KURITZKY
ARCHITECT

CITY OF DELRAY CRA
CARVER ISLE

DELRAY BEACH, FLORIDA


PROJECT NO. 1807

DATE: 11-01-18

REVISIONS

SITE PLAN

A-1.0
DESIGN DEVELOPMENT

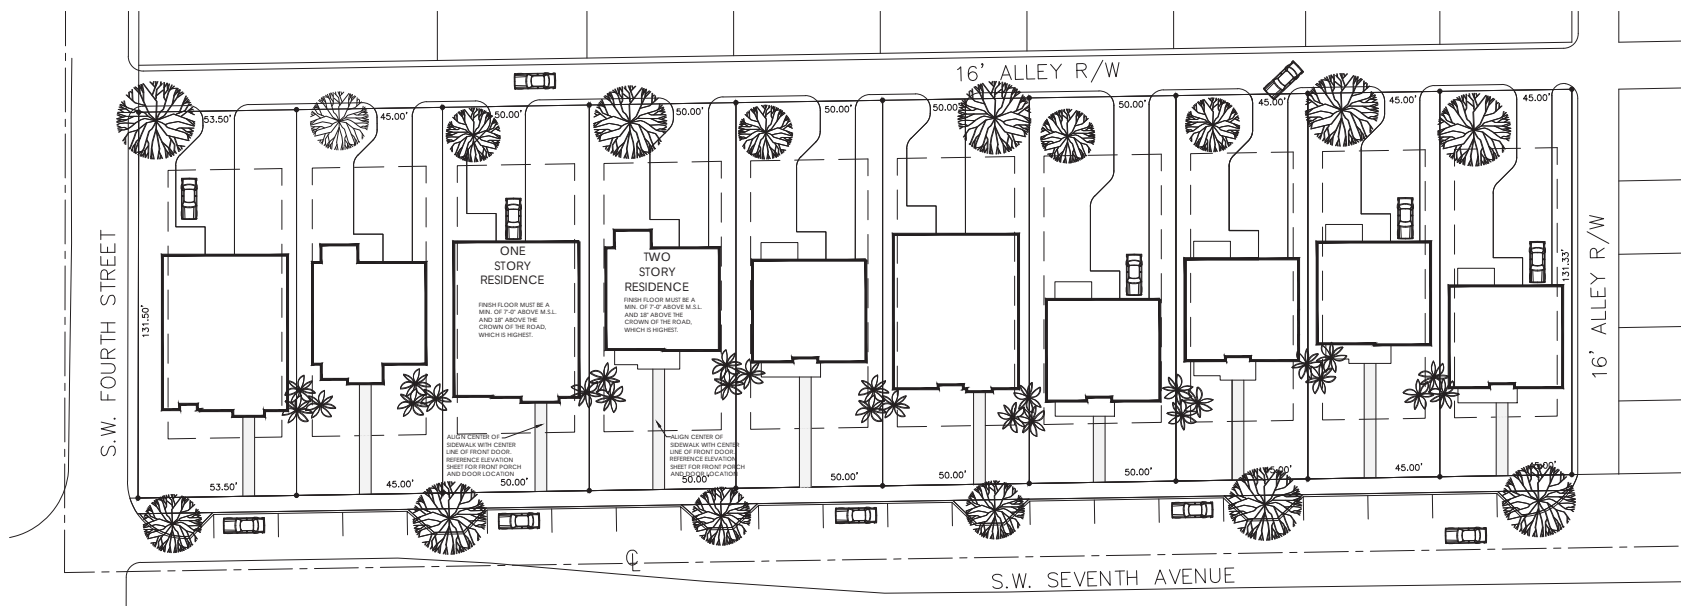

SITE PLAN
SCALE 1" = 20'-0"

SITE PLAN AND BUILDING DATA	LEGAL DESCRIPTION (ABBREVIATED):	LEGAL DESCRIPTION (ABBREVIATED):	LEGAL DESCRIPTION (ABBREVIATED):