

BUILDING SETBACKS:

BUILDING SETBACK SHOWN ON PLAN

ZONING:
PC - PLANNED COMMERCIAL

LEGEND


EXISTING

EXISTING BUILDING
LAND LOT LINE (LLL)
PROPERTY LINE
UTILITY POLE (UP), OVERHEAD LINE & GUY
TREE LINE
SANITARY SEWER MANHOLE (SSMH)
FIBER OPTIC CABLE
FIBER OPTIC LINE, OUT (FOL)

ELECTRICAL TRANSFORMER BOX
FIRE HYDRANT
WATER VALVE
GAS VALVE
WATER STUB OUT
WATER METER
GAS METER
ELECTRIC METER

0 20' 30' 40'
SCALE IN FEET

48 HOURS BEFORE YOU DIG

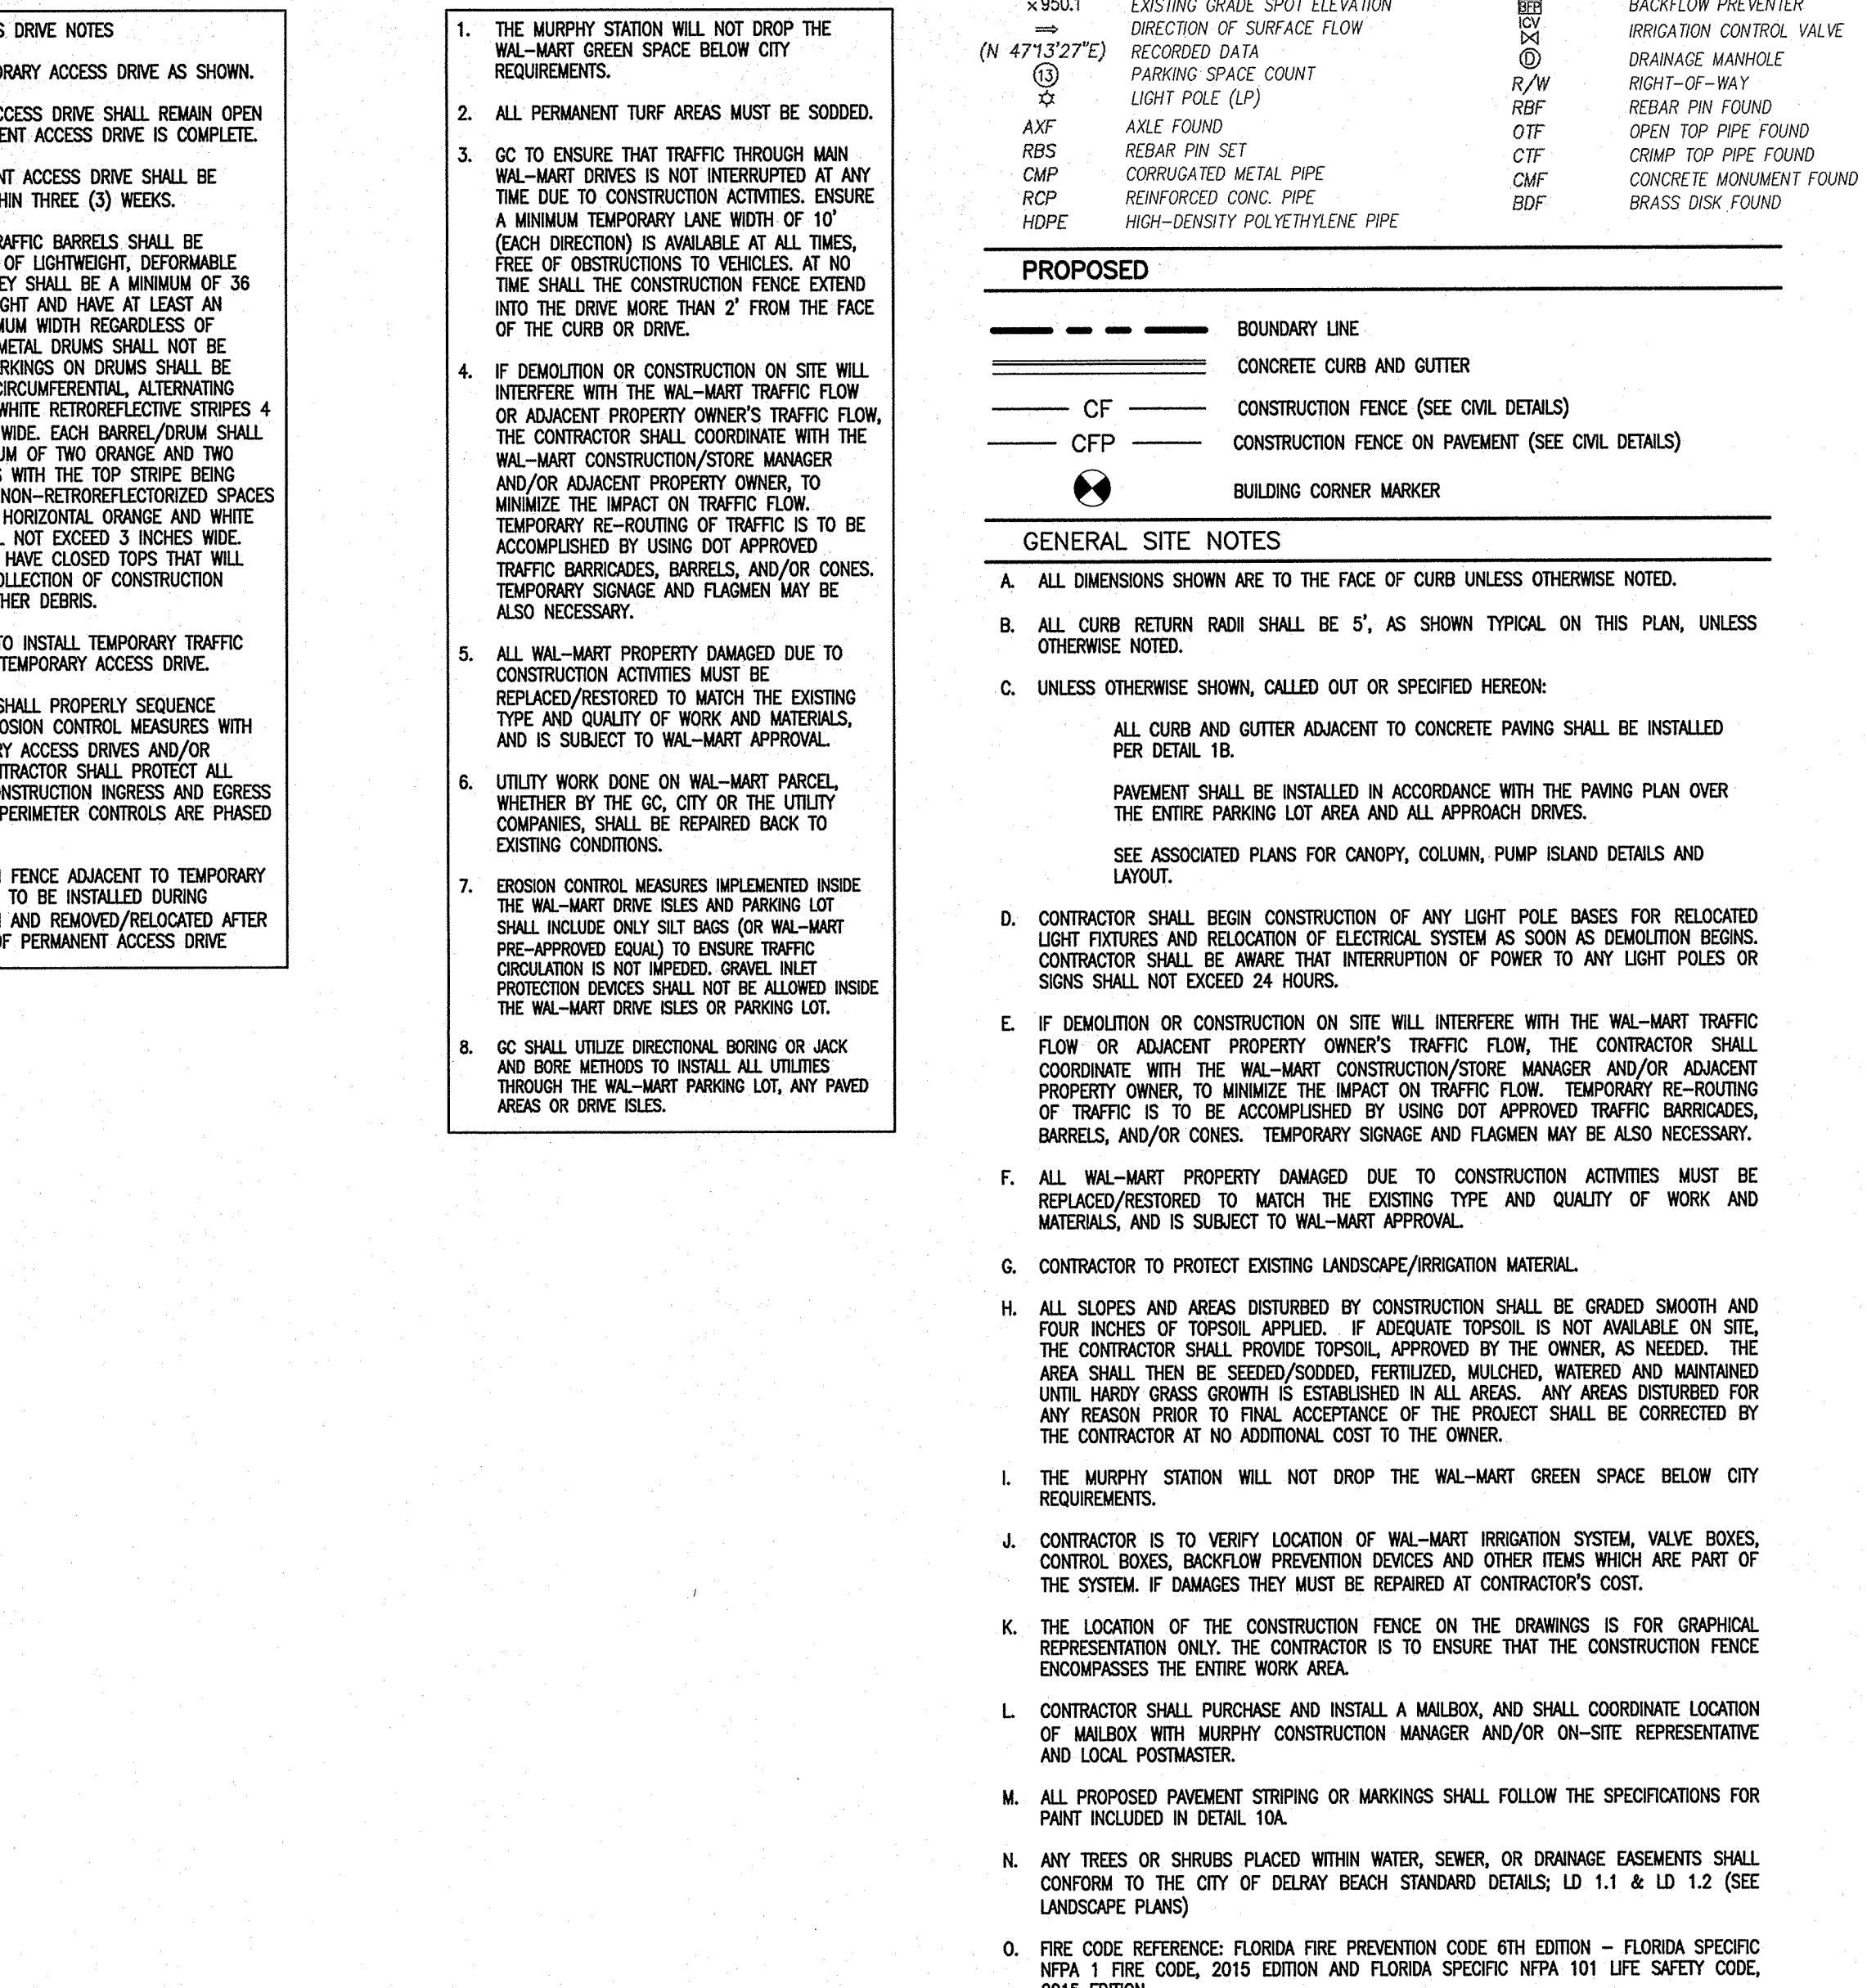

SITE NOTES		SITE DETAILS — SEE DETAIL SHEETS	
2F	DRILL (2) 3/4" x 5/8" DIA. HOLES (1) EACH FOR OPEN POSITION & CLOSED POSITION OF GATES. TO BE USED ON BOTH SIDES OF GATE. SEE DIMPSTER DETAIL.	1B	TYPE "B" CONCRETE CURB & GUTTER.
8B	OVERHEAD CANOPY — (TYP.—PER CANOPY PLANS)	2B	DUMPSTER ENCLOSURE.
12E	PEDESTRIAN CROSSING—4" WIDE PAINTED WHITE STRIPES. 2.0' C.O. @ 45' (SEE SIZE INDICATED AT SYMBOL.)	2F	CONSTRUCTION SAFETY FENCE
12H	4" DOUBLE TRAFFIC YELLOW LANE STRIPE (SEE LENGTH INDICATED AT SYMBOL.)	3D	CONCRETE SIDEWALK
12M	CONTRACTOR TO ENSURE THAT ANY LIGHT POLES OR HANDICAP PARKING SIGNS ARE AT LEAST 2' FROM BACK OF CURB TO PREVENT THE VEHICLES FROM STRIKING THESE ITEMS.	3M	WHEELCHAIR RAMP IN SIDEWALK (FDOT STANDARD DRAWING 522-001 TYPE CR-D)
14J	GC TO INSTALL (1) 4" PVC SLEEVE FOR IRRIGATION LINE. SEE UTILITY PLAN FOR INSTALLATION REQUIREMENTS.	5A	GUARD POST (SINGLE)
14K	GC TO INSTALL (2) 4" PVC SLEEVES FOR FUTURE USE. SEE UTILITY PLAN FOR INSTALLATION REQUIREMENTS.	5B	TRAFFIC SIGN IN BOLLARD
16B	MURPHY OIL FREESTANDING SIGN. PER APPROVED ELEVATION. (8'-0" TALL)	5C	STREET SIGN (CITY STD. RT 2.1B)
21A	TAPER CURB TO MATCH EXISTING CURB	5G	U-BUMPER DETAIL
21B	TAPER CURB HEIGHT FROM 6" TO 0" OVER 5'	9S	ACCESSIBLE / VAN ACCESSIBLE PARKING SIGN (TYP.)
21C	EDGE OF CONCRETE SLAB. PER TANK/PIPING PLANS.	9U	ACCESSIBLE PARKING SYMBOL. (SEE PAINT COLOR INDICATED AT SYMBOL.)
21E	UNDERGROUND STORAGE TANKS (1) 25,000 GAL—REGULAR, (1) 8,000 GAL—PREMIUM, (1) 10,000 GAL—DIESEL, (1) 8,000 GAL—E-O.	9V	ACCESSIBLE PARKING (CITY STD. RT 4.2A)
21G	AIR VACUUM UNIT WITH 4' x 7' CONCRETE SLAB	10A	TRAFFIC FLOW ARROW (TYP.)
21H	MURPHY USA ID SIGN. PER APPROVED ELEVATION.	10B	STOP BAR (TYP.)
21L	PRICE SIGN PER APPROVED ELEVATION	11K	"NO PARKING" SIGN"
21P	PROPANE TANK. CAGE LOCATION.	12B	BICYCLE RACK — SEE CITY OF DELRAY BEACH DETAIL RT 13.1 ON SHEET C-13
21T	MAILBOX (CONTRACTOR TO COORDINATE LOCATION WITH MURPHY AND POSTMASTER PRIOR TO INSTALLATION).	12C	BICYCLE BLOCK
21U	ICE UNIT LOCATION.	12G	"STOP" SIGN
21V	CONCRETE PAD FOR VENT RISERS. PER TANK & PIPING PLANS.	13A	SITE LIGHT POLE. SEE PHOTOMETRIC PLANS FOR POLE BASE DETAIL, FIXTURE TYPE, AND MOUNTING DETAILS.

MURPHY OIL USA, INC. MURPHY USA★		GreenbergFarrow 1430 W. PELACHTREET ST. NW SUITE 200 ATLANTA, GA. 30399 PHONE: (404) 601 4000 FAX: (404) 601 3970 DWG NAME: DELRAY BEACH, FL JOB NO.: 201504850		200 PEACH STREET P.O. BOX 7000 EL DORADO, AR 71730-7000	
REV-5	DATE	JN	CB	DS	DRW
		PRN	PM	DES	

SITE PLAN

WALMART SUPERCENTER #1589

16211 S. MILITARY TRAIL

DELRAY BEACH FLORIDA