

Gregory B. Makins
FL REG. # AR33534
DATE: 12-29-18

THIS DOCUMENT IS THE PROPERTY OF CBM ARCHITECTURE PA. IT IS TO BE USED ONLY FOR THE PROJECT AND SITE SPECIFICALLY IDENTIFIED HEREIN. NO PART OF THIS DOCUMENT IS TO BE REPRODUCED OR TRANSMITTED IN ANY FORM OR BY ANY MEANS, ELECTRONIC OR MECHANICAL, INCLUDING PHOTOCOPYING, RECORDING, OR BY ANY INFORMATION STORAGE AND RETRIEVAL SYSTEM.

CBM
ARCHITECTURE PA

ARCHITECTURE
MASTER PLANNING
A43603332

26.0 U.S. GWS ARE REQUIRED, UNLESS OTHERWISE NOTED.
T: 954.713.6101
P: 954.812.6680
E: GREG@CBMARCHITECTURE.COM
WEB: WWW.CBMARCHITECTURE.COM

PALM BEACH COUNTY

DELRAY BEACH FORD
2501 SOUTH FEDERAL HIGHWAY
DELRAY BEACH, FL 33483

CITY OF DELRAY BEACH

DRAWING ISSUE DATES:
10.1.19-1.6.19: CITY COMMENTS

12.29.18: COORD. REVISION


SITE PLAN
PHOTOMETRIC

SHEET

PH -2


PROJECT 1.61.02D
DATE 12-29-18
PERMIT NO.

AA Mount

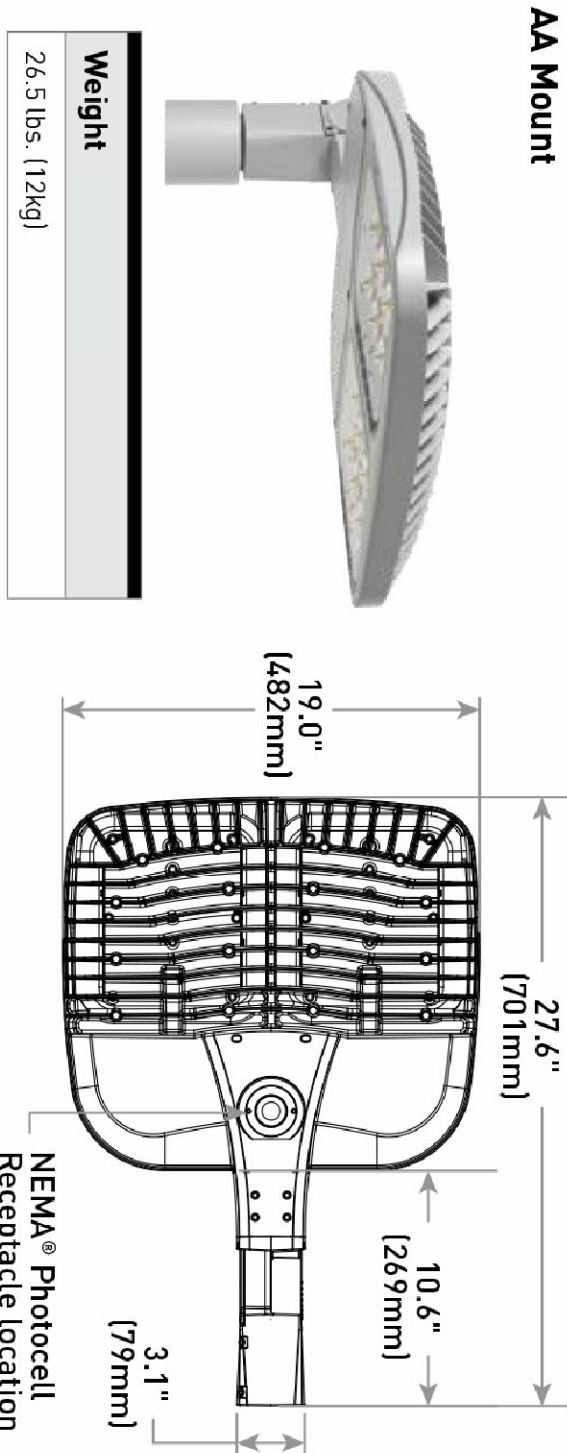

NEMA® Protocol
Recessed location
(ordered as an option)

RR/RL Configuration

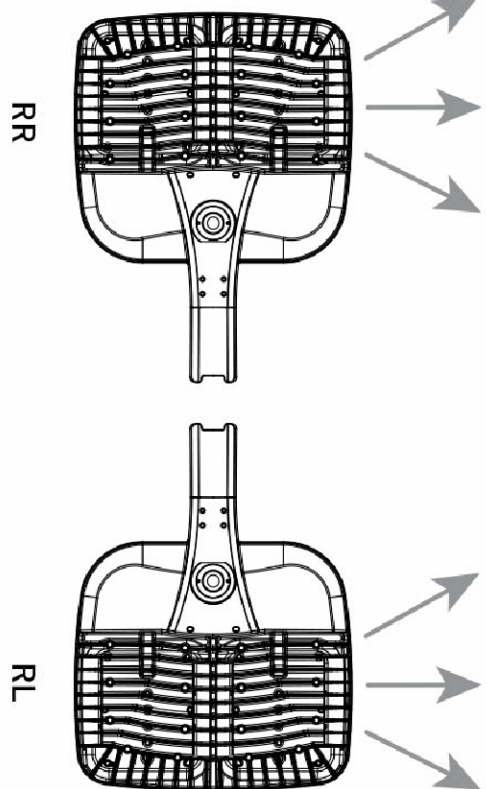

© 2018 Cree, Inc. and/or one of its subsidiaries. All rights reserved. For informational purposes only. Content is subject to change. Patent www.cree.com/patents. Cree®, the Cree logo, NanoDot®, and ColorCast Delux® are registered trademarks, and Precision Delivery Grid™ and OSQM are trademarks of Cree, Inc. The UL logo is a registered trademark of UL LLC. NEMA® is a registered trademark of the National Electrical Manufacturers Association. The DLC®PL logo and the DLC®PL Premium logo are registered trademarks of Efficiency Forward, Inc.


US: lighting.cree.com T: (800) 236-6800 F: (262) 504-5415

Canada: www.cree.com/canada



T: (800) 473-1234 F: (800) 890-7507

Site Lighting Fixture Detail

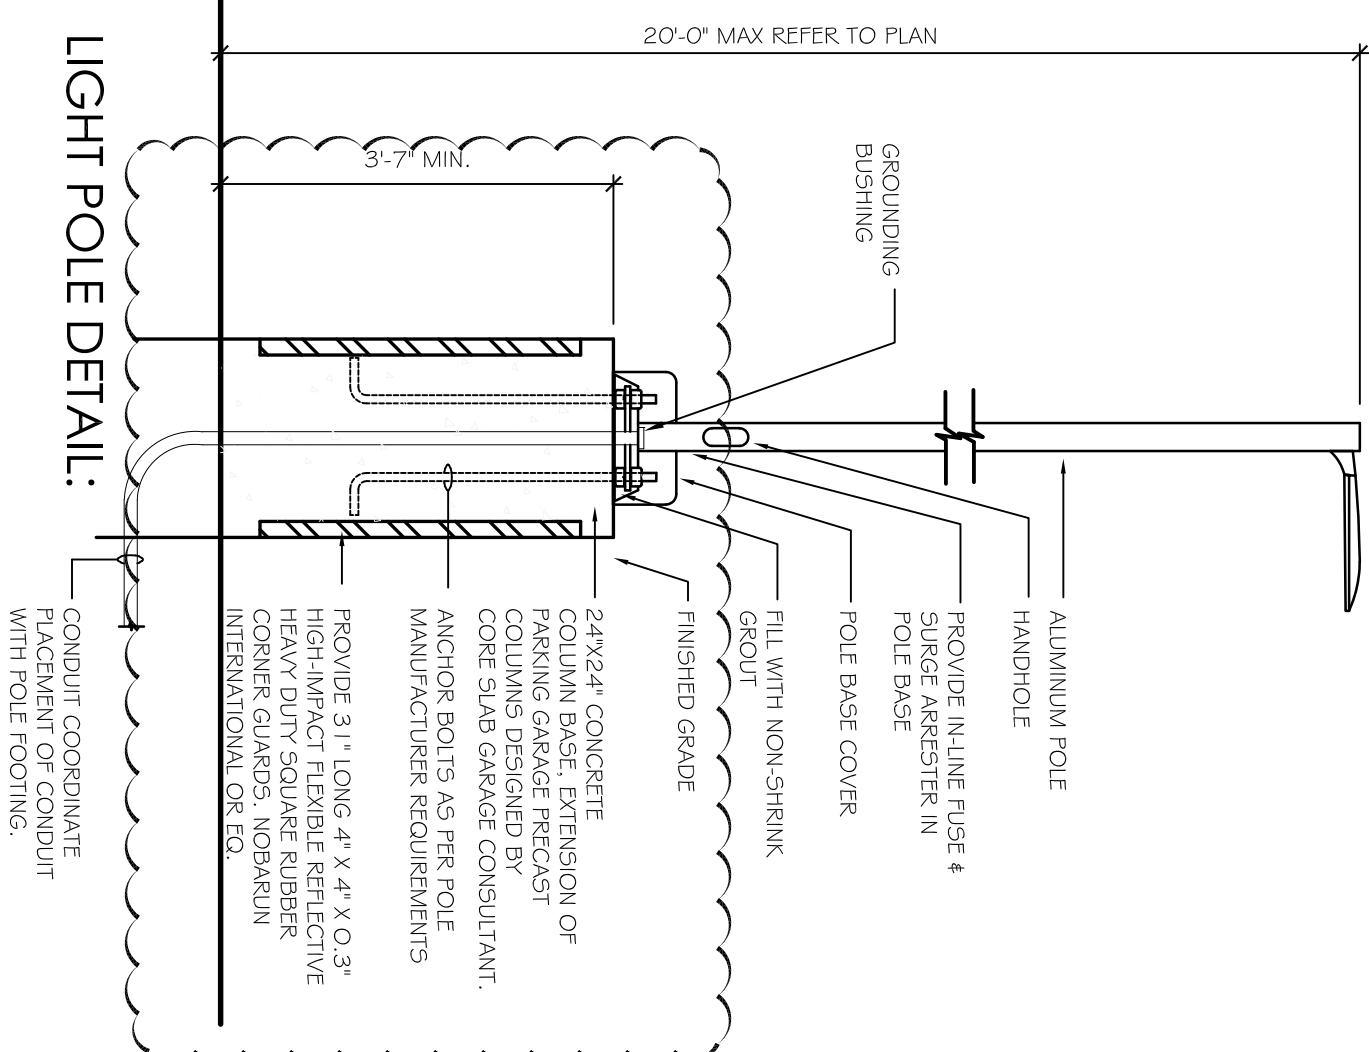

LIGHT POLE DETAIL:

CONDUIT COORDINATE
PLACEMENT OF CONDUIT
WITH POLE FOOTING.




Calculation Summary			
Project: FORD DEALERSHIP - ROOF TOP REV 12-28-20		DELRAY BEACH, FL	
		Reference: FPM-4L-2018-12-19.A01	
Label	CalcType	Units	
PROPERTY LINE EAST	Illuminance	Fc	0.00
PROPERTY LINE NORTH	Illuminance	Fc	0.00
PROPERTY LINE SOUTH	Illuminance	Fc	0.00
PROPERTY LINE WEST	Illuminance	Fc	0.00
ROOF TOP	Illuminance	Fc	4.52
			5.8
			1.3
			3.45
			5.16

Calc. Summary

Luminaire Schedule			
Symbol	Qty	Description	LLF
6	SET	CREE LTG # (2) OSO-A-5NIE-U-40K-UL / MTD AT 20' AVG	0.900
			24666

Luminaire Schedule

Roof Photometric Roof Level Plan

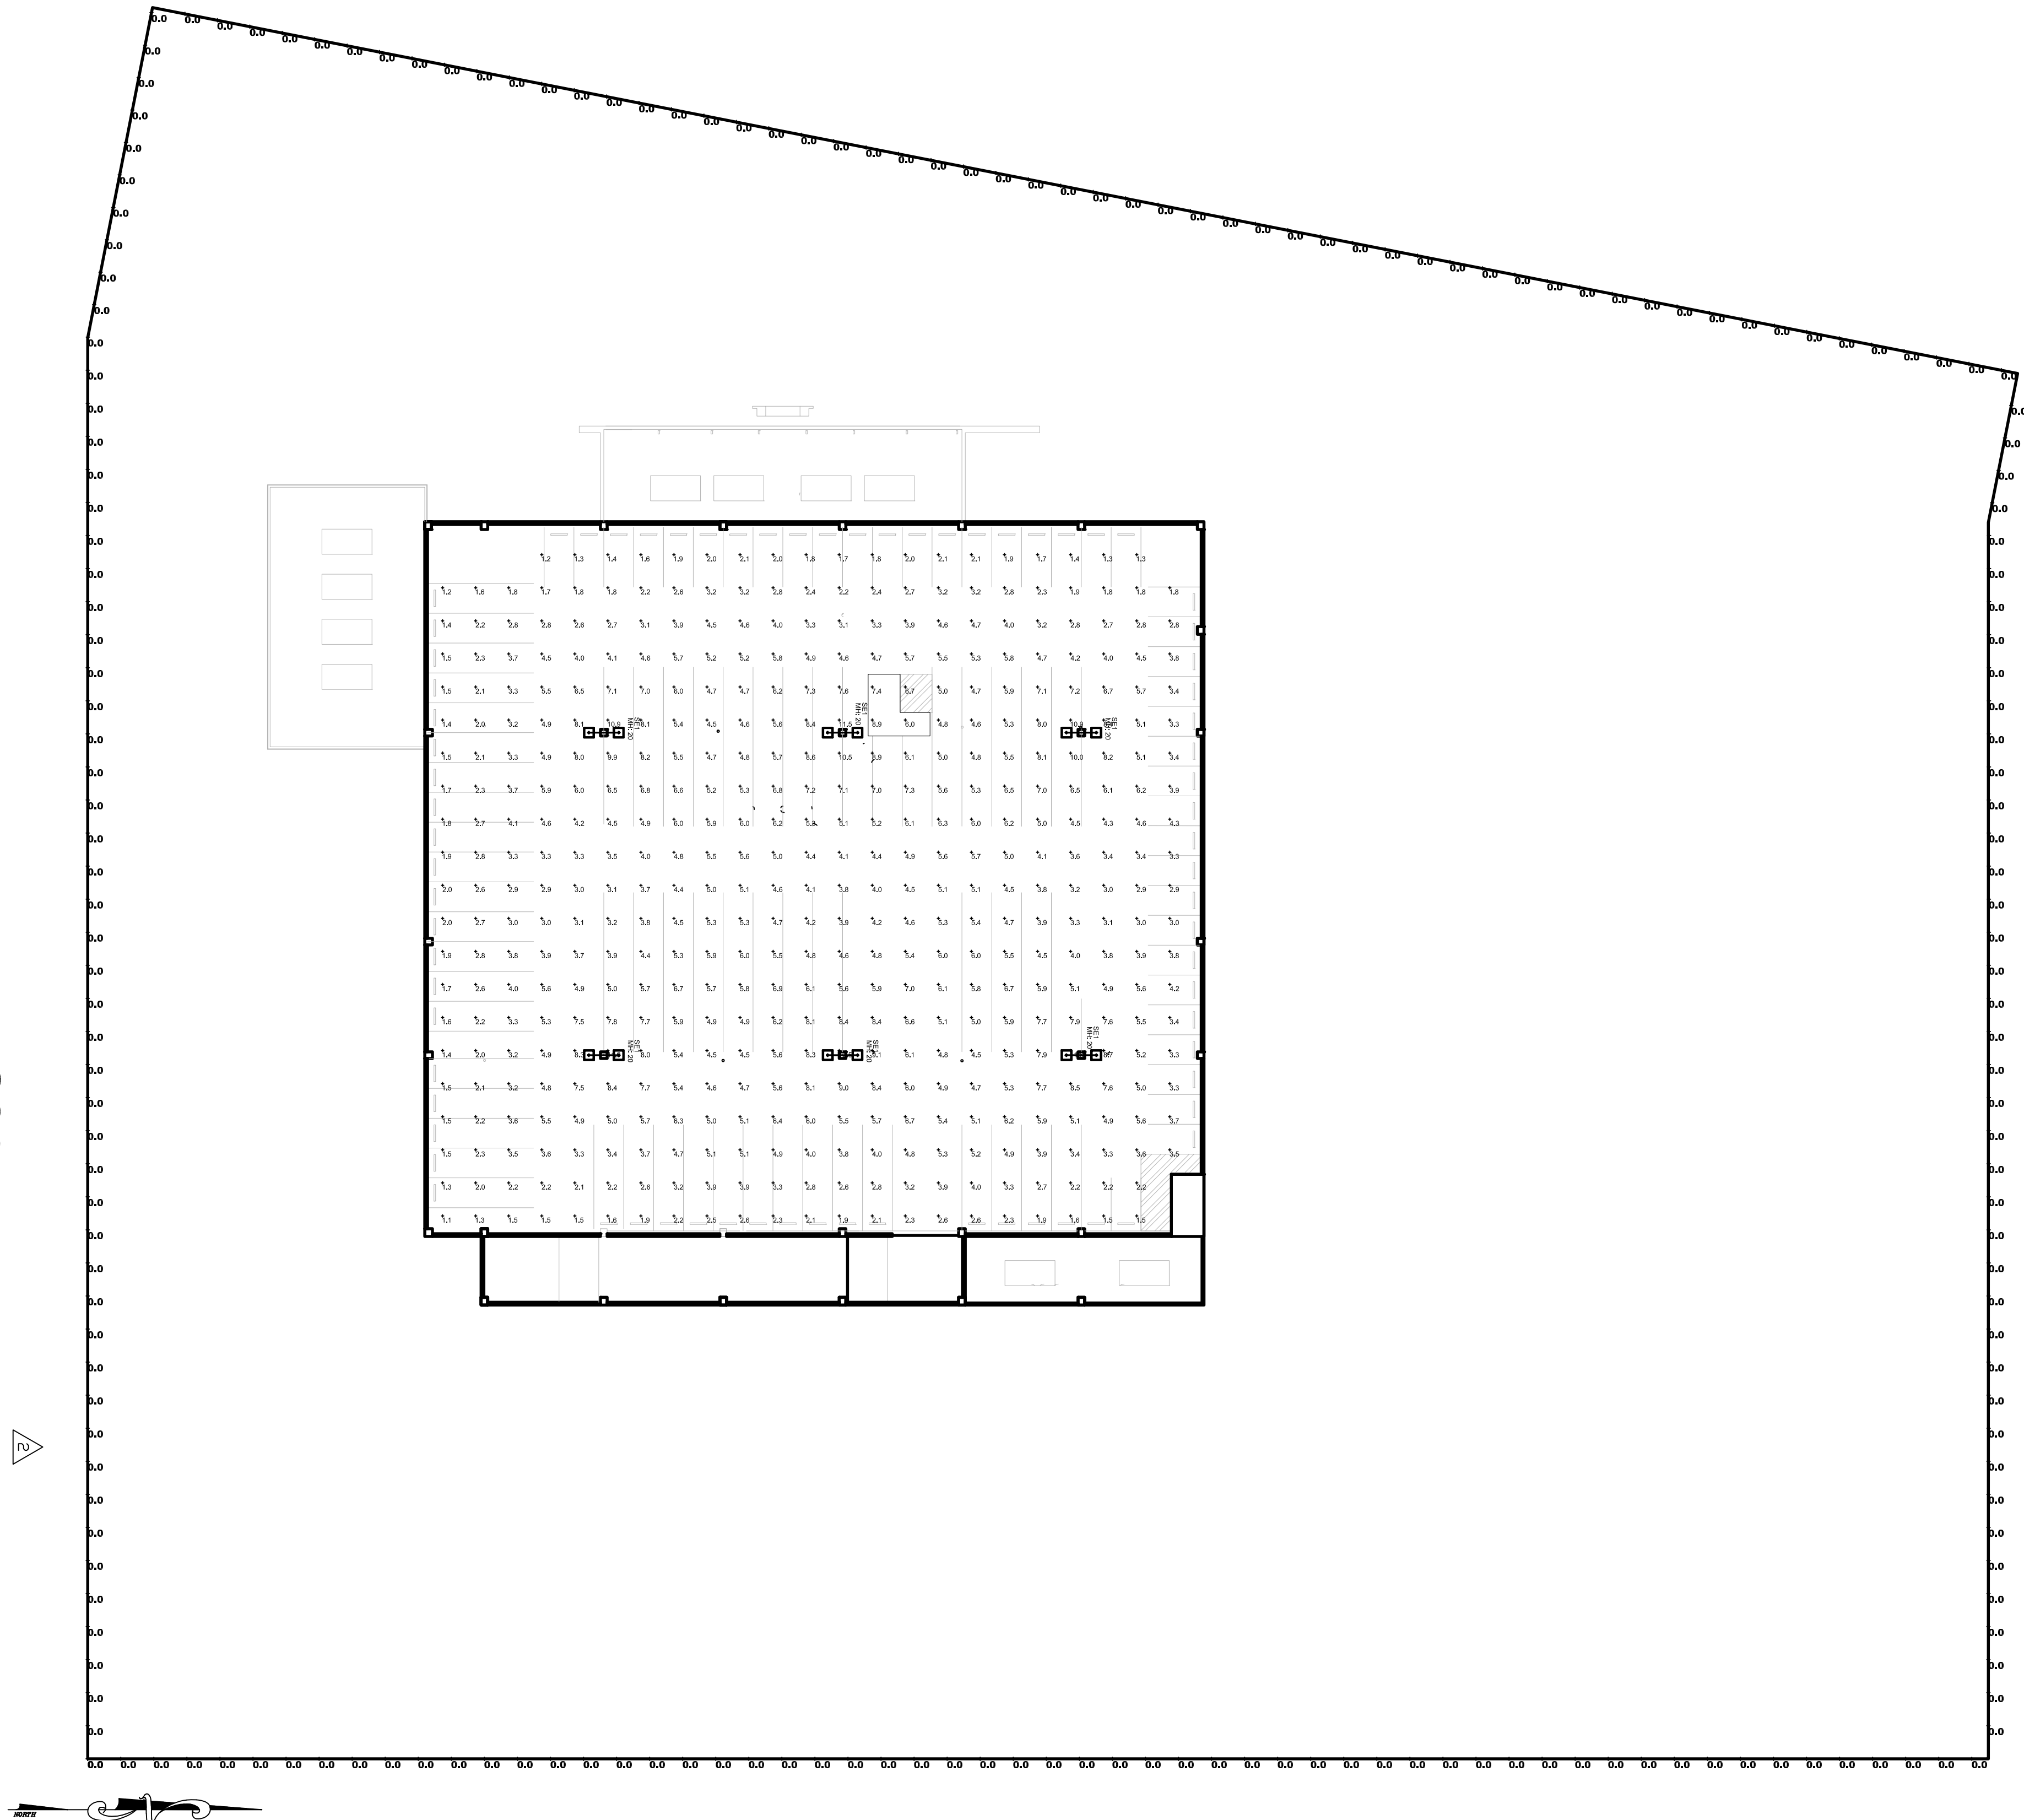

Scale : 1" = 30' - 0"

02

Roof Level Lighting Details

01