


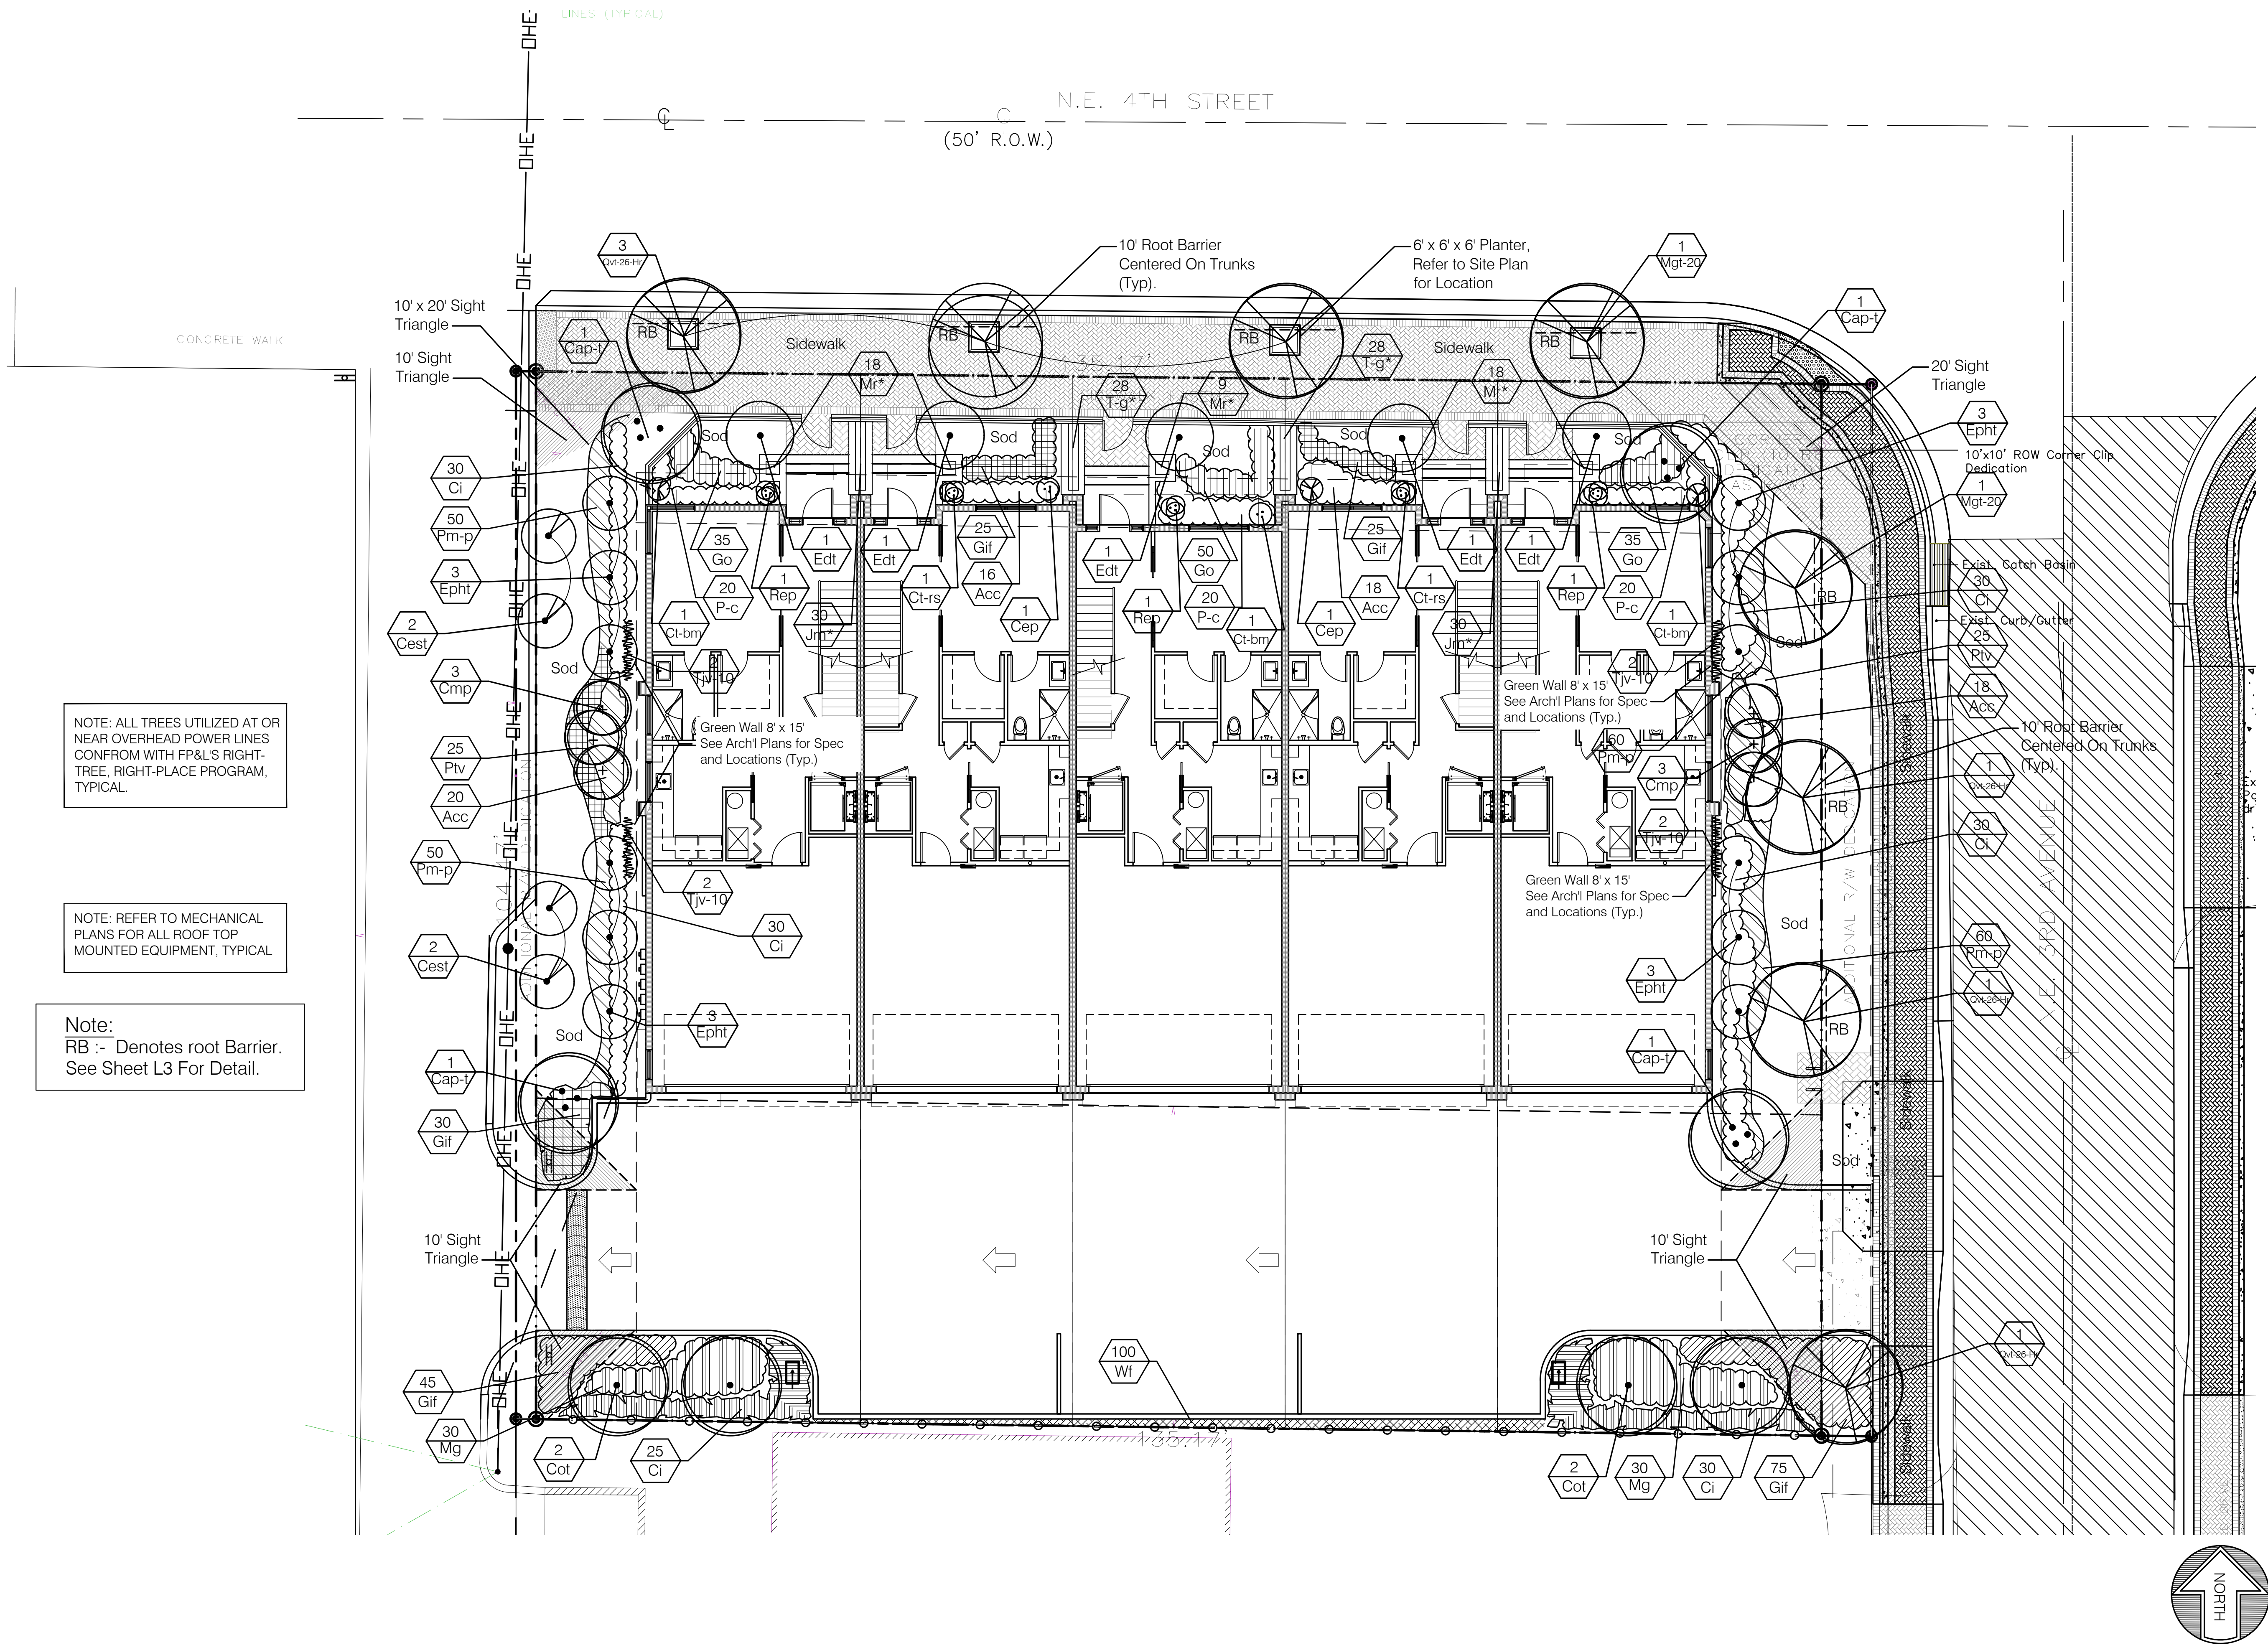

NOTE: ALL TREES UTILIZED AT OR NEAR OVERHEAD POWER LINES CONFROM WITH FP&L'S RIGHT-TREE, RIGHT-PLACE PROGRAM, TYPICAL.

NOTE: REFER TO MECHANICAL PLANS FOR ALL ROOF TOP MOUNTED EQUIPMENT, TYPICAL

Note:
RB :- Denotes root Barrier.
See Sheet L3 For Detail.

REVISIONS	BY
Revised 12/3/18 Per City Comments, Tree Mitigation	
Revised 2/14/19 Per Revised Site Plan	

DESIGNED BY:
CARTER & ASSOCIATES
LANDSCAPE ARCHITECTS INC.
74 N.E. 5th AVE. Delray Beach, FL 33483
LA. 831
561-272-9621

Landscape & Irrigation Plans for:
TOWNHOMES
AT 214 4TH
214 NE 4TH STREET
Delray Beach, Florida 33444

DRAWN	SKP
CHECKED	D.H.C.
DATE	2/7/18
SCALE	1/8" = 1'-0"
JOB NO.	121517
SHEET	