



Architect, Planner and Designer
AA-26002044


1045 East Atlantic Ave. Suite 303
Delray Beach, Florida 33483
TEL: 561-276-6011
FAX: 561-276-6129

ISSUED FOR

BIDS

PERMIT

CONSTRUCTION

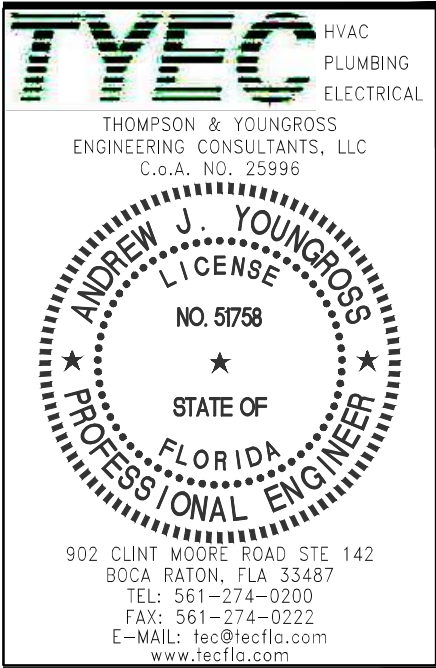

PROJECT TITLE

MARINE
VILLAS ON
MARINE WAY

110 MARINE WAY
DELRAY BEACH, FL.

CLIENT APPROVAL

REVISIONS

1 P&Z COMMENTS 9.26.2019


FILE NUMBER 19097_PSP-1

DRAWING TITLE

PHOTOMETRIC
SITE PLAN


DATE 7-2-2019 DRAWN BY TYEC
JOB NUMBER 20180802 / 19097
DRAWING NUMBER

PSP-1

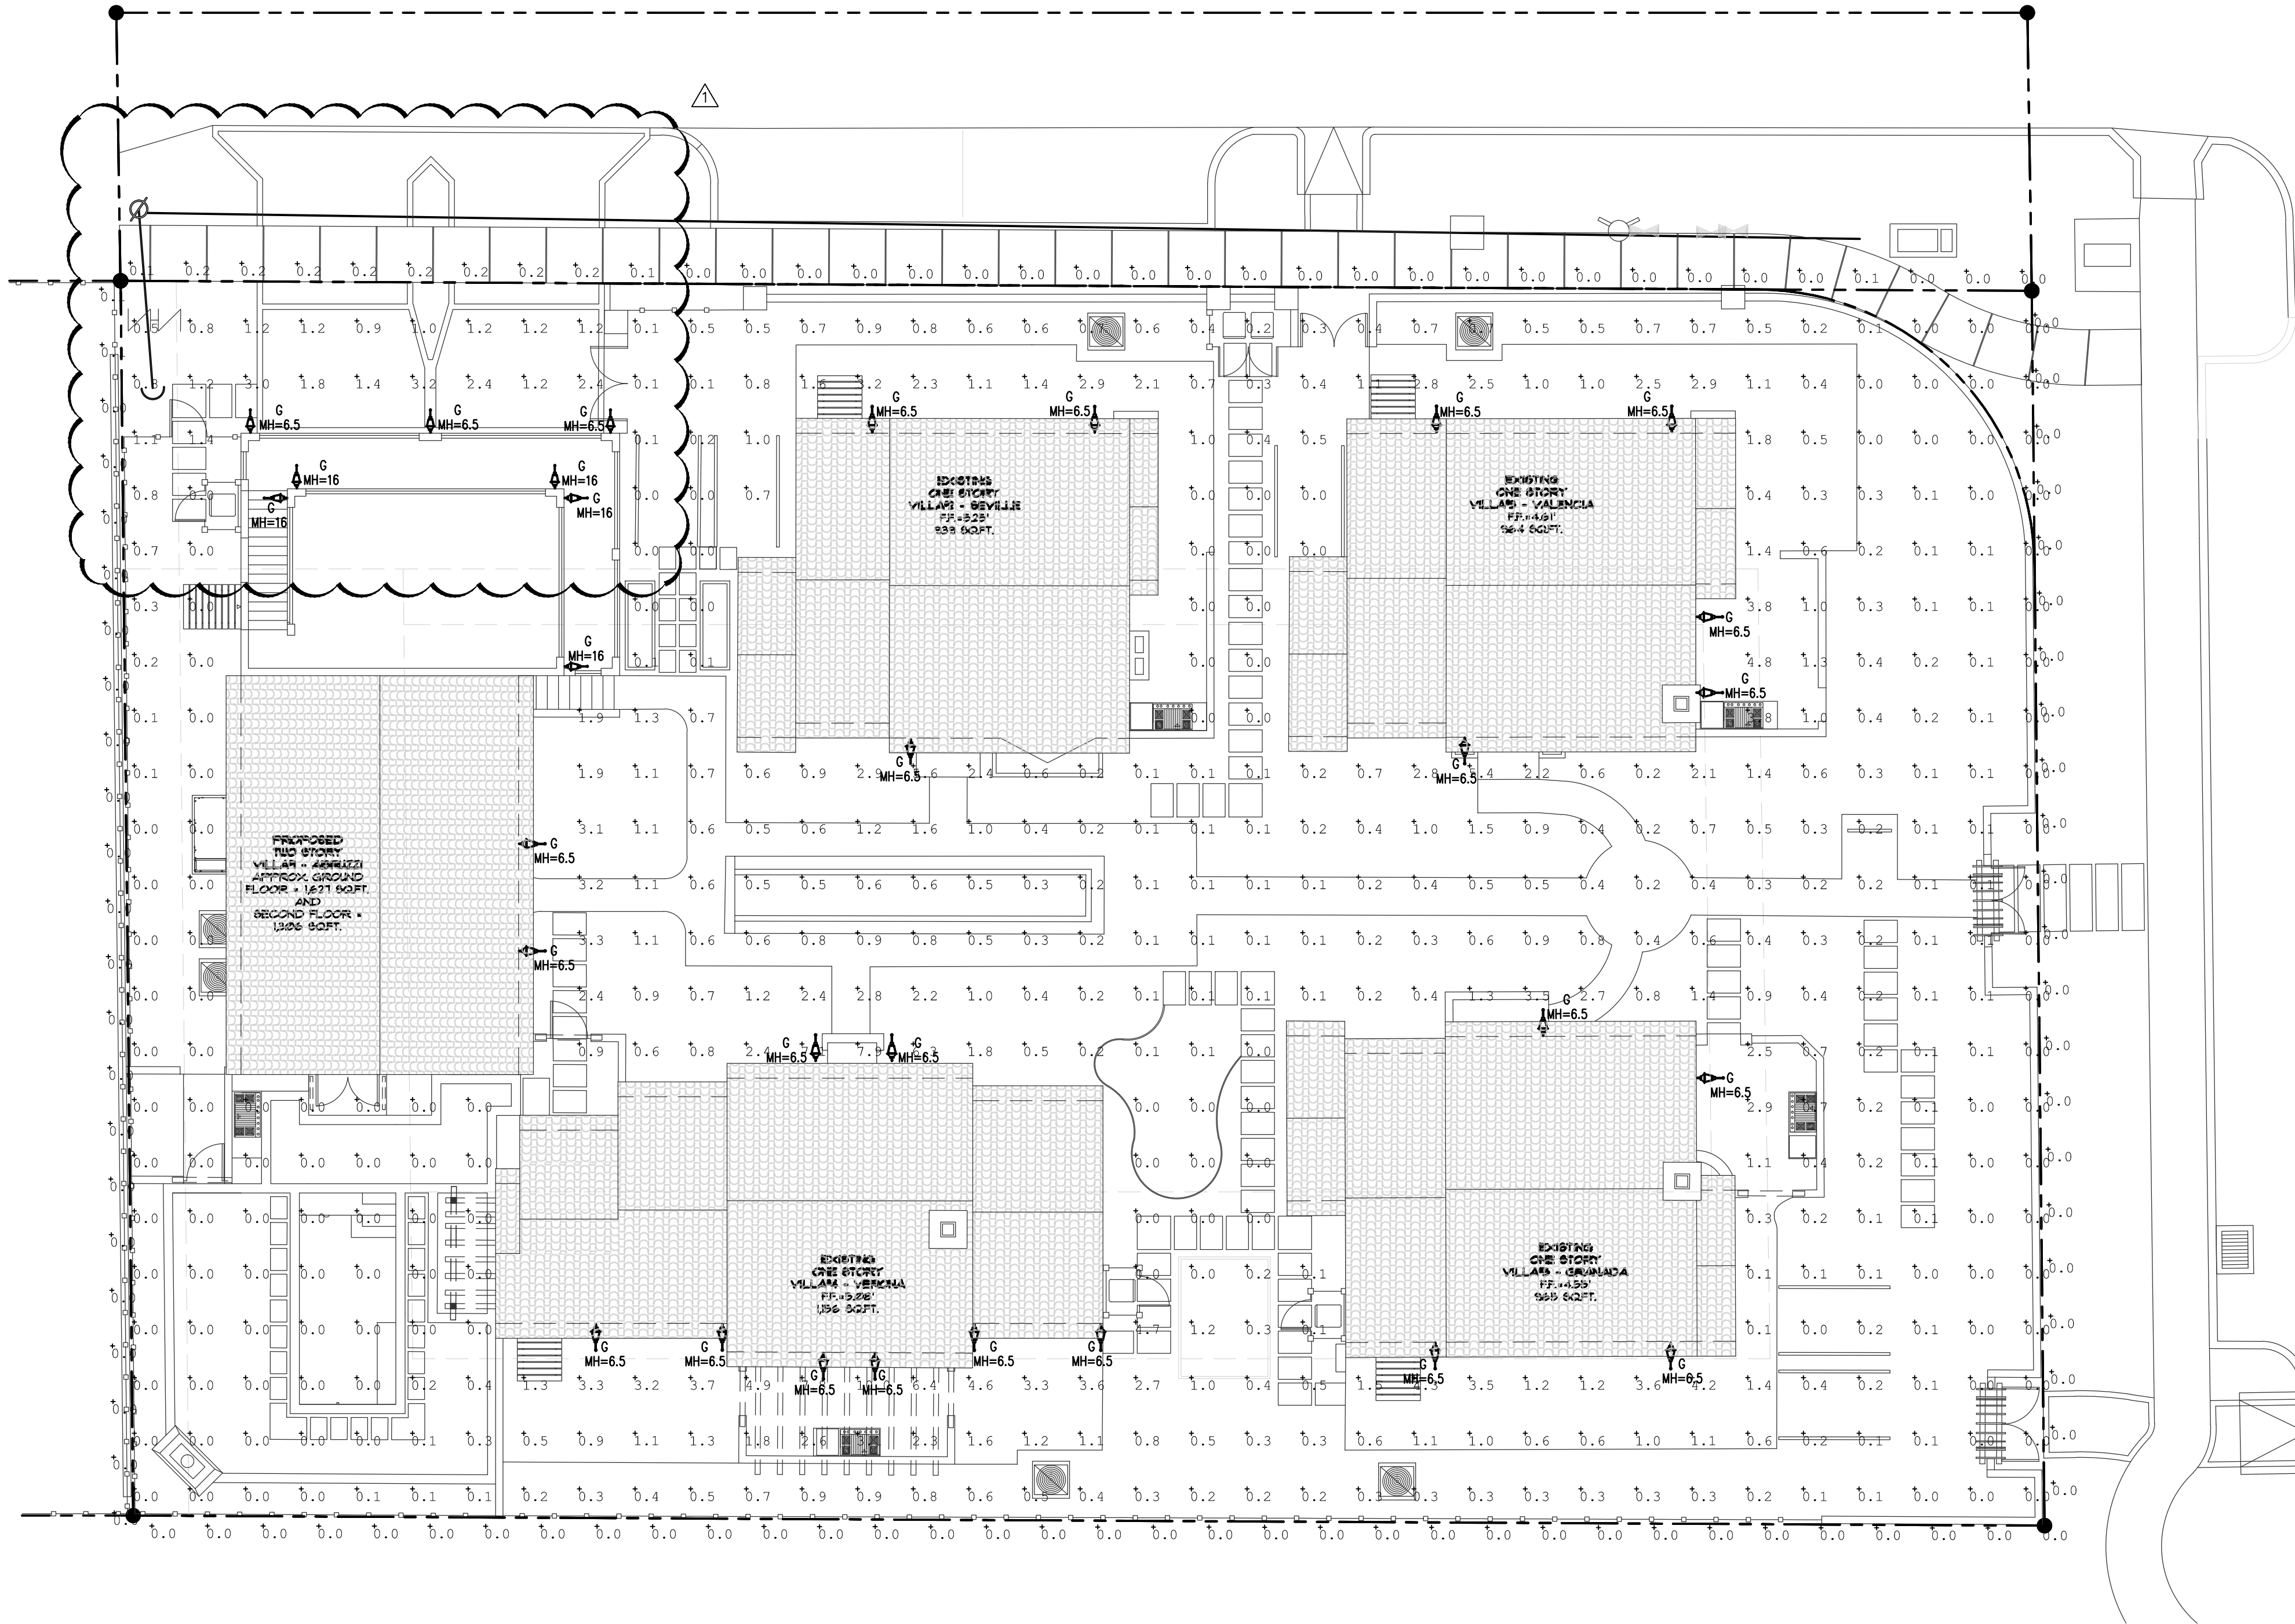

PHOTOMETRIC SITE PLAN

SCALE : 1" = 10'-0"

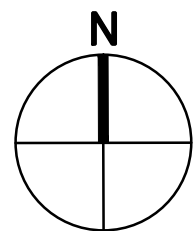

HINKLEY & R.

HINKLEY LIGHTING, INC.
3300 PIN OAK PARKWAY | AVON LAKE, OHIO 44012
(PH) 330.653.5500 | (FAX) 330.653.5555
HINKLEYLIGHTING.COM | FREDRIKRAMOND.COM



Small Wall Mount Lantern 1850LZ

ITEM NUMBER	1850LZ
BRAND	Hinkley Lighting
MATERIAL	Aluminum
GLASS	Clear
HEIGHT	13.0"
WIDTH	7.0"
VOLTAGE	120V
WATTAGE	1-100w Med.
CERTIFICATION	C-US Wet Rated
EXTENSION	6.0"
TOP TO OUTLET	7.8"
BACK PLATE	4.5"W X 6"H

- Suitable for use in wet (interior direct splash and outdoor direct rain or sprinkler) locations as defined by NEC and CEC.
- Meets United States UL Underwriters Laboratories & CSA Canadian Standards Association Product Safety Standards
- For complete warranty information visit (hyperlink)
- 2 year finish warranty
- 12 year warranty on electrical wiring and components
- The Heritage Collection encompasses premium outdoor fixtures that pay tribute to the nostalgia of America's past while reinforcing Hinkley's philosophy of timeless, quality design.
- Classic lines and heritage details complement traditional architecture
- Warm rich light bronze tone

FINISH Light Oiled Bronze

AT HINKLEY, WE EMBRACE THE DESIGN PHILOSOPHY THAT YOU CAN MERGE TOGETHER THE LIGHTING, FURNITURE, ART, COLORS AND ACCESSORIES YOU LOVE INTO A BEAUTIFUL ENVIRONMENT THAT DEFINES YOUR OWN PERSONAL STYLE. WE HOPE YOU WILL BE INSPIRED BY OUR COMMITMENT TO KEEP YOUR LIFE AGLOW.

lifeAGLOW™

LUMINAIRE SCHEDULE

LABEL	DESCRIPTION	MFG	CATALOG NUMBER	LAMPING	LUMENS	WATTS	LLF
G	DECORATIVE WALL SCONCE "ANCHORAGE"	HINKLEY LIGHTING	1850LZ	LED	1300	16	0.9

CALCULATION SUMMARY

LABEL	Units	Avg	Max	Min	Avg/Min	Max/Min
PRIVATE INTERIOR COURTYARD & GARAGE DRIVEWAY	Fc	0.1	0.2	0.0	N.A.	N.A.
PROPERTY LINE	Fc	0.1	0.2	0.0	N.A.	N.A.

NOTE

THESE DRAWINGS ARE PREPARED PER ESTABLISHED INDUSTRY STANDARDS AND REPRESENT THE ENGINEERS DESIGN CONCEPT. THEY ARE NOT INTENDED TO PROVIDE EVERY DETAIL OR CONDITION REQUIRED TO CONSTRUCT THE BUILDING. THE CONTRACTOR THROUGH SUBMITTALS AND OTHER COORDINATION EFFORTS IS FULLY RESPONSIBLE FOR PROVIDING A COMPLETE AND OPERATIONAL BUILDING WHETHER INDICATED ON THE PLANS OR NOT.