
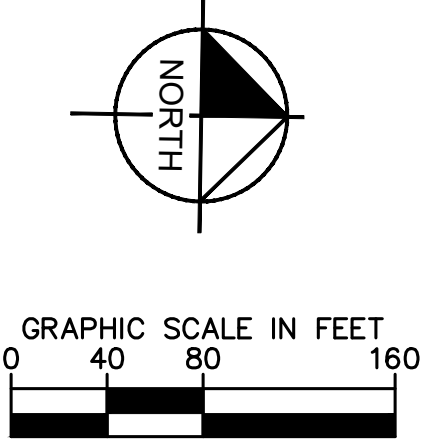


Plotted By: Villalón, Teresa Sheet Set: 1690 - 2350 S. Congress Avenue Layout: C11.00 MASTER COMPOSITE PLAN November 03, 2020 02:04:36pm K:\BDC_Civil\140248002 - CentrePointe\CADD\PlanSheets\C11.00 MASTER INFRASTRUCTURE PLAN.dwg

This document, together with the concepts and designs presented herein, as an instrument of service, is intended only for the specific purpose and client for which it was prepared. Reuse of and improper reliance on this document without written authorization and adaptation by Kimley-Horn and Associates, Inc. shall be without liability to Kimley-Horn and Associates, Inc.

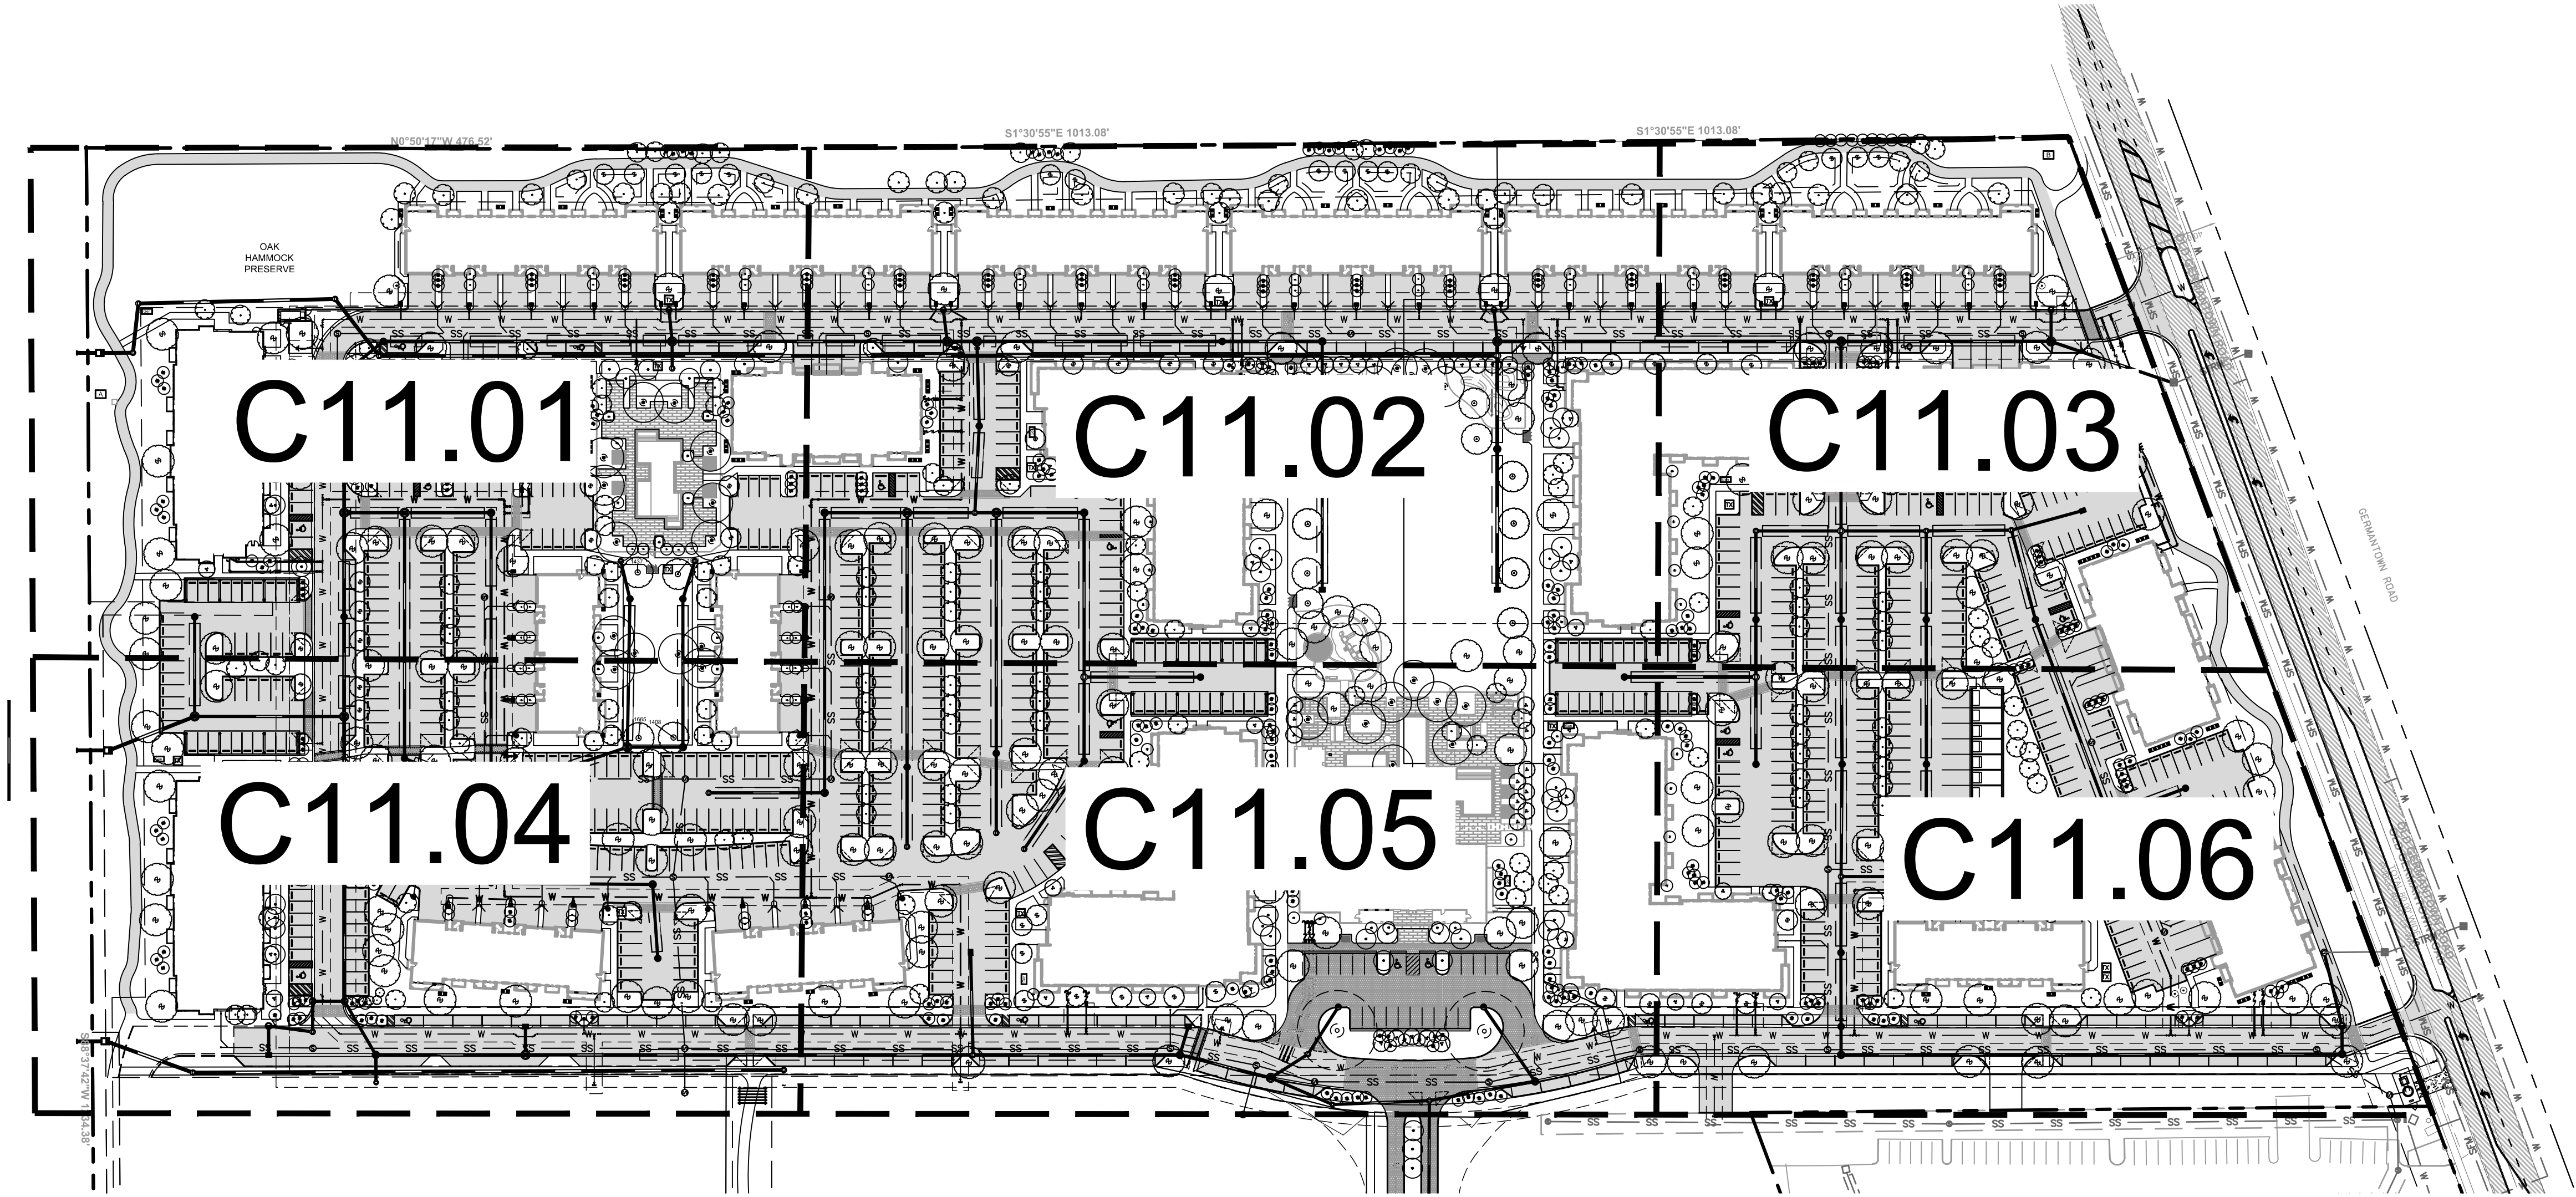


- LEGEND:**
- PROPOSED STORM PIPE
 - PROPOSED SAN. SEWER MAIN
 - PROPOSED POTABLE WATERMAIN
 - PROPOSED SAN. SEWER MANHOLE
 - PROPOSED DRAINAGE MANHOLE
 - PROPOSED CURB INLET
 - PROPOSED TYPE 'C' INLET

1690 - 2350 S. CONGRESS AVENUE PREPARED FOR 13TH FLOOR INVESTMENTS DELRAY BEACH FLORIDA	MASTER COMPOSITE PLAN	KHA PROJECT 140248002 DATE NOV. 2020 SCALE AS SHOWN DESIGNED BY JVP DRAWN BY B/J CHECKED BY MDS	LICENSED PROFESSIONAL MICHAEL D. SPRUCE, P.E. FLORIDA LICENSE NUMBER 52776 DATE: _____	Kimley»Horn © 2020 KIMLEY-HORN AND ASSOCIATES, INC. 1615 S CONGRESS AVE., SUITE 201, DELRAY BEACH, FL 33445 PHONE: 561-330-2345 FAX: 561-863-8175 WWW.KIMLEY-HORN.COM CA 00000696	REVISIONS		BY
					No.	DATE	

Plotted By: Shelef, Arie Sheet Set: 1690 - 2350 S. Congress Avenue Layout: C11.01 COMPOSITE PLAN November 03, 2020 11:23:07am K:\bldg-cv\140248002 - centrepointe\CADD\plansheets\C11.01 COMPOSITE PLAN.dwg
This document, together with the concepts and designs presented herein, as an instrument of service, is intended only for the specific purpose and client for which it was prepared. Reuse of and improper reliance on this document without written authorization and adaptation by Kimley-Horn and Associates, Inc. shall be without liability to Kimley-Horn and Associates, Inc.



PALM BEACH COUNTY CANAL #62

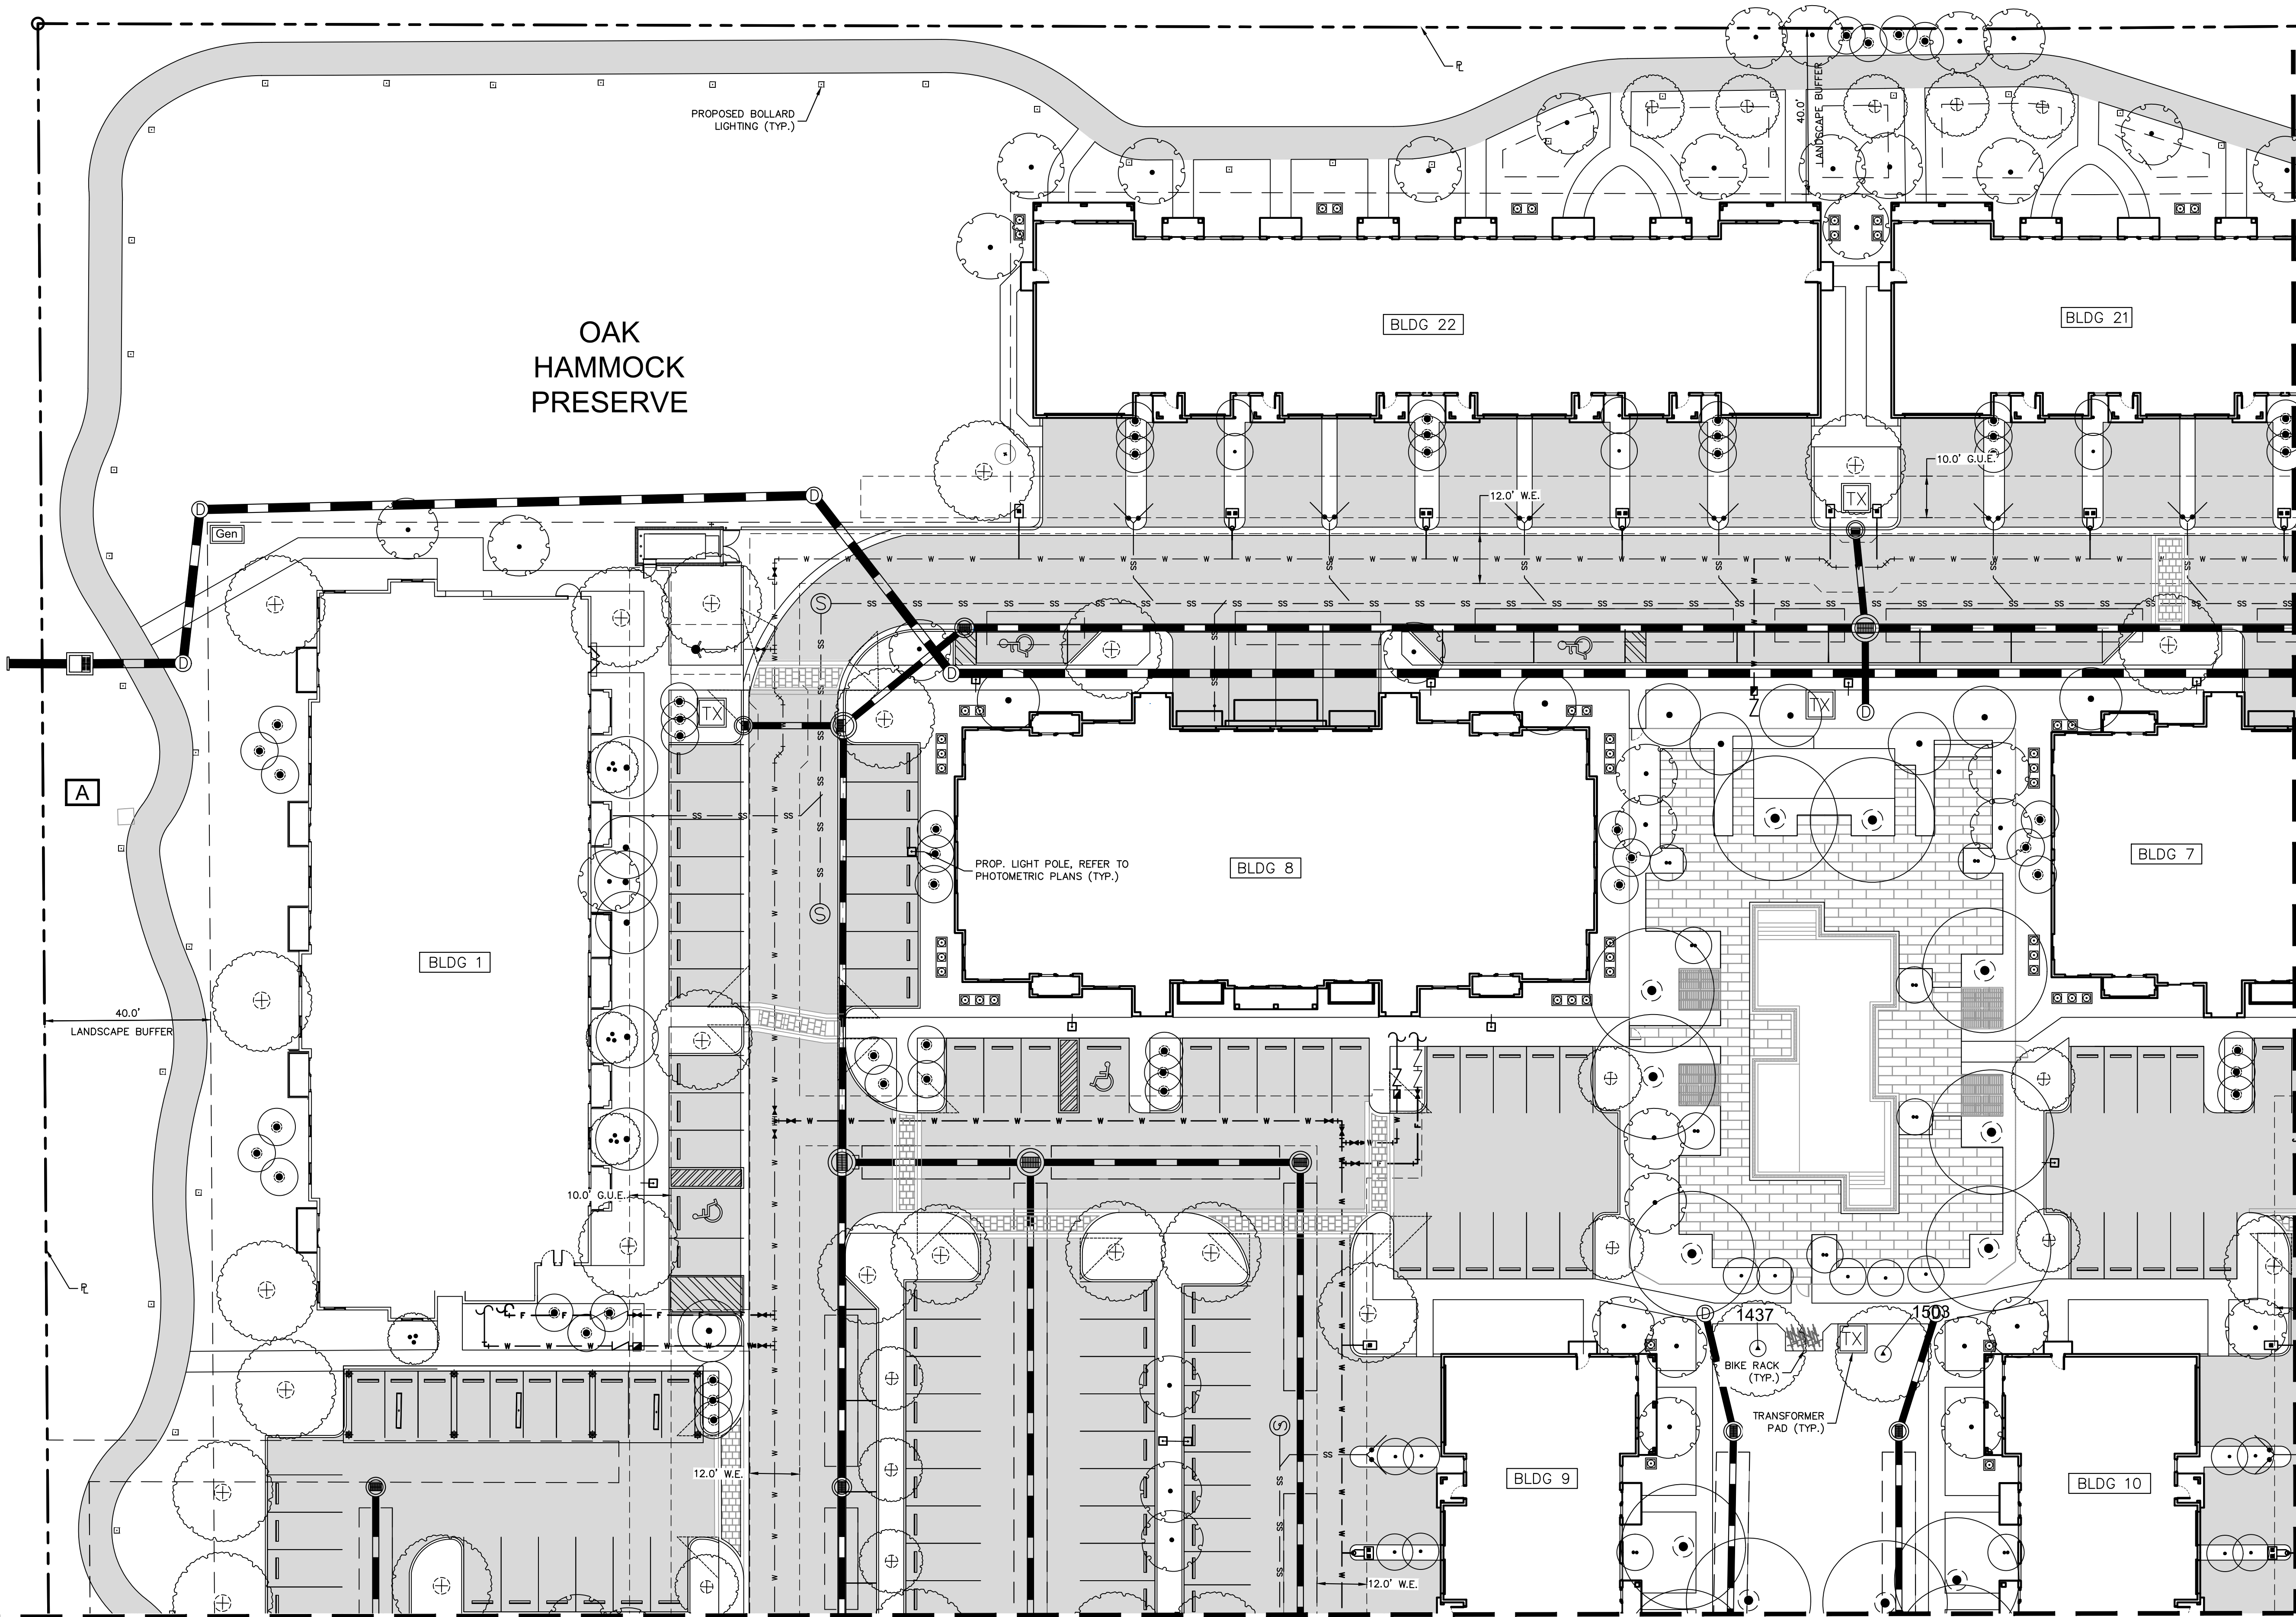

MATCHLINE - SEE SHEET C11.04

MATCHLINE - SEE SHEET C11.02


- LEGEND:
- PROPOSED STORM PIPE
 - PROPOSED SAN. SEWER MAIN
 - PROPOSED POTABLE WATERMAIN
 - PROPOSED SAN. SEWER MANHOLE
 - PROPOSED DRAINAGE MANHOLE
 - PROPOSED CURB INLET
 - PROPOSED TYPE 'C' INLET

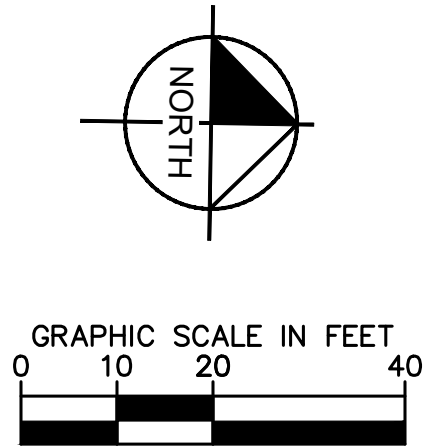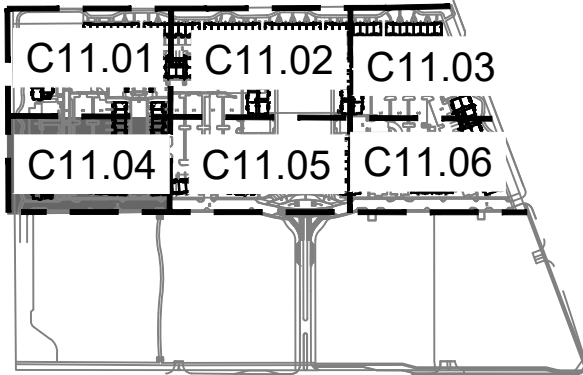

1690 - 2350 S. CONGRESS AVENUE PREPARED FOR 13TH FLOOR INVESTMENTS FLORIDA		COMPOSITE PLAN		Kimley»Horn © 2020 KIMLEY-HORN AND ASSOCIATES, INC. 1615 S CONGRESS AVE, SUITE 201, DELRAY BEACH, FL 33445 PHONE: 561-330-2345 FAX: 561-863-8175 WWW.KIMLEY-HORN.COM CA 00000696		REVISIONS		BY	
SHEET NUMBER C11.01		DATE NOV. 2020		LICENSED PROFESSIONAL MICHAEL D. SPRUCE, P.E.		NO.		DATE	
DESIGNED BY JVP		SCALE AS SHOWN		FLORIDA LICENSE NUMBER 52776		REVISIONS		BY	
DRAWN BY B/J		CHECKED BY MDS		DATE		REVISIONS		BY	

Plotted By: Villalon, Teresa Street Set: 1690 - 2350 S. Congress Avenue Layout: C3.02 COMPOSITE PLAN November 03, 2020 01:35:48pm K:\BCD_Civil\140248002 - CentrePointe\CADD\PlanSheets\C11.01 COMPOSITE PLAN.dwg

This document, together with the concepts and designs presented herein, as an instrument of service, is intended only for the specific purpose and client for which it was prepared. Reuse of and improper reliance on this document without written authorization and adaptation by Kimley-Horn and Associates, Inc. shall be without liability to Kimley-Horn and Associates, Inc.


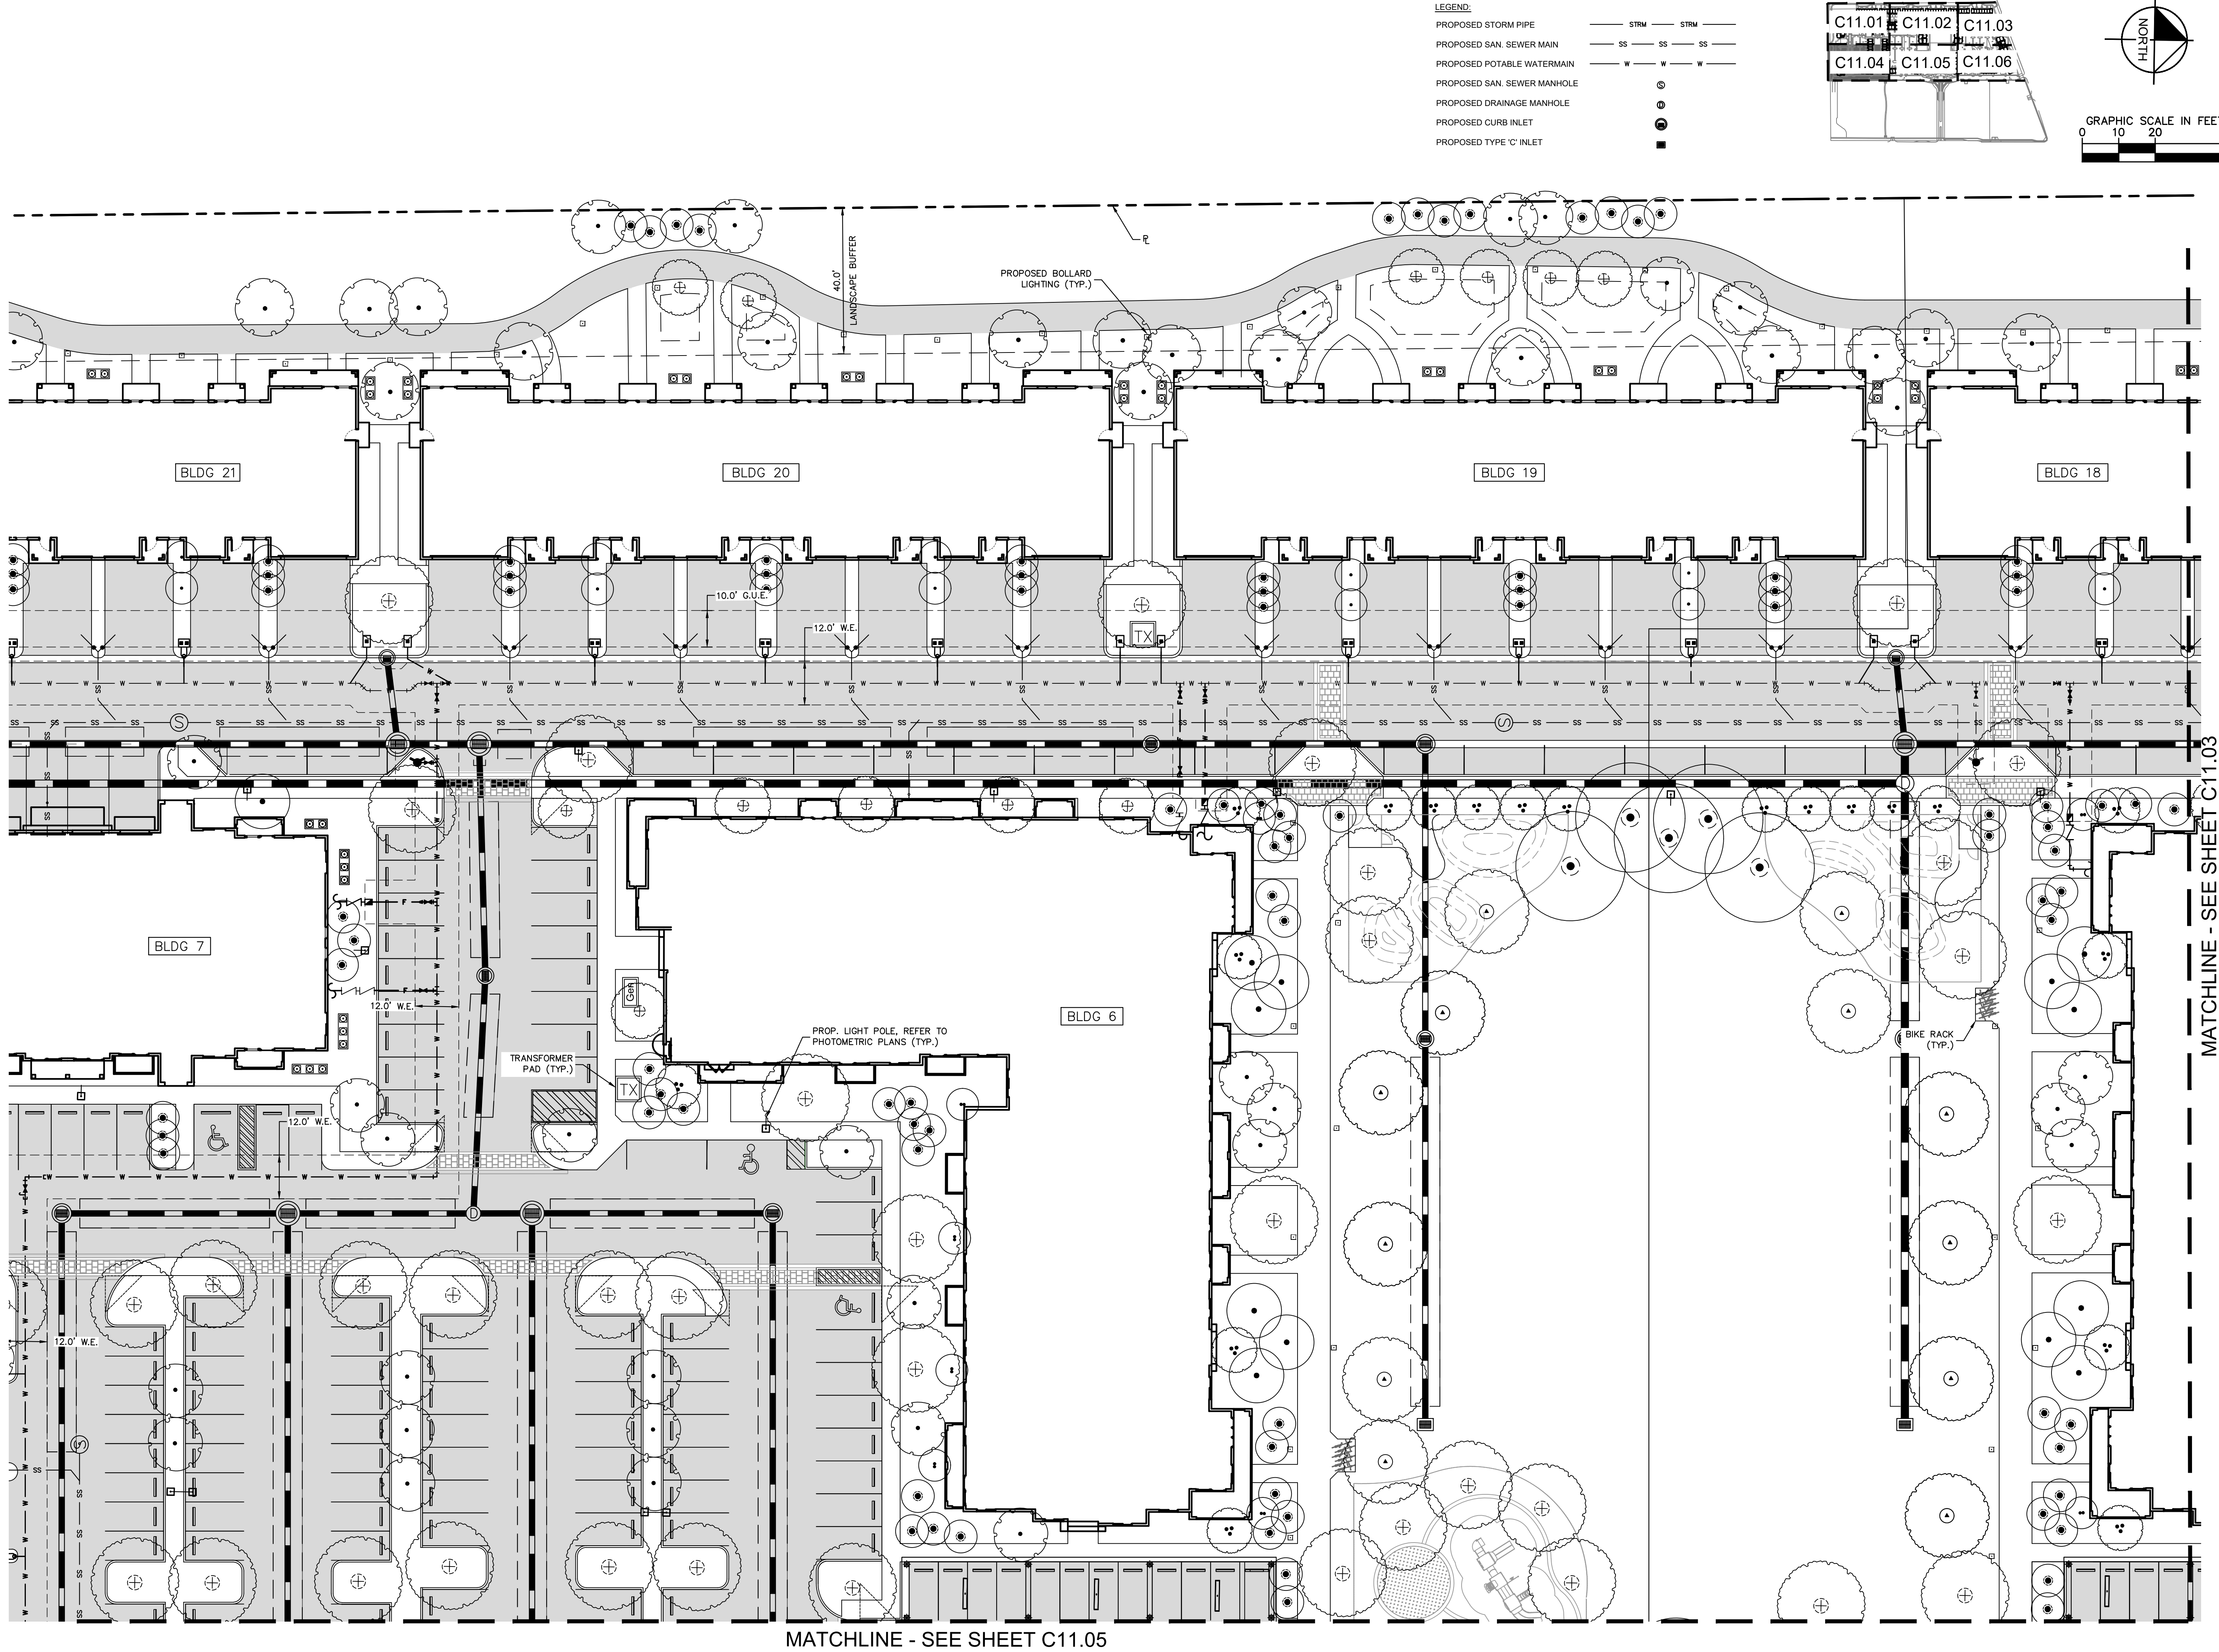


1690 - 2350 S. CONGRESS AVENUE PREPARED FOR 13TH FLOOR INVESTMENTS FLORIDA	COMPOSITE PLAN		KIMLEY»HORN © 2020 KIMLEY-HORN AND ASSOCIATES, INC. 1615 S CONGRESS AVE, SUITE 201, DELRAY BEACH, FL 33445 PHONE: 561-330-2345 FAX: 561-863-8175 WWW.KIMLEY-HORN.COM CA 00000696
	KHA PROJECT 140248002		
	DATE NOV. 2020		
SCALE AS SHOWN		MICHAEL D. SPRUCE, P.E.	
DESIGNED BY JVP		FLORIDA LICENSE NUMBER 52776	
DRAWN BY B/J		CHECKED BY MDS	
DATE		DATE	

Plotted By: Villalon, Teresa Street Set: 1690 - 2350 S. Congress Avenue Layout: C3.03 COMPOSITE PLAN November 03, 2020 02:12:47pm K:\BCD-Civil\140248002 - CentrePointe\CADD\PlanSheets\C11.01 COMPOSITE PLAN.dwg



This document, together with the concepts and designs presented herein, as an instrument of service, is intended only for the specific purpose and client for which it was prepared. Reuse of and improper reliance on this document without written authorization and adaptation by Kimley-Horn and Associates, Inc. shall be without liability to Kimley-Horn and Associates, Inc.

MATCHLINE - SEE SHEET C3.02

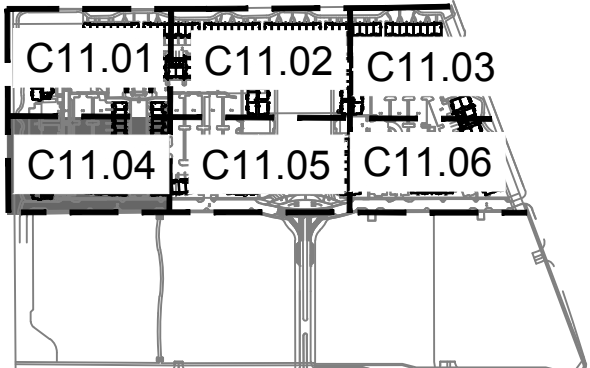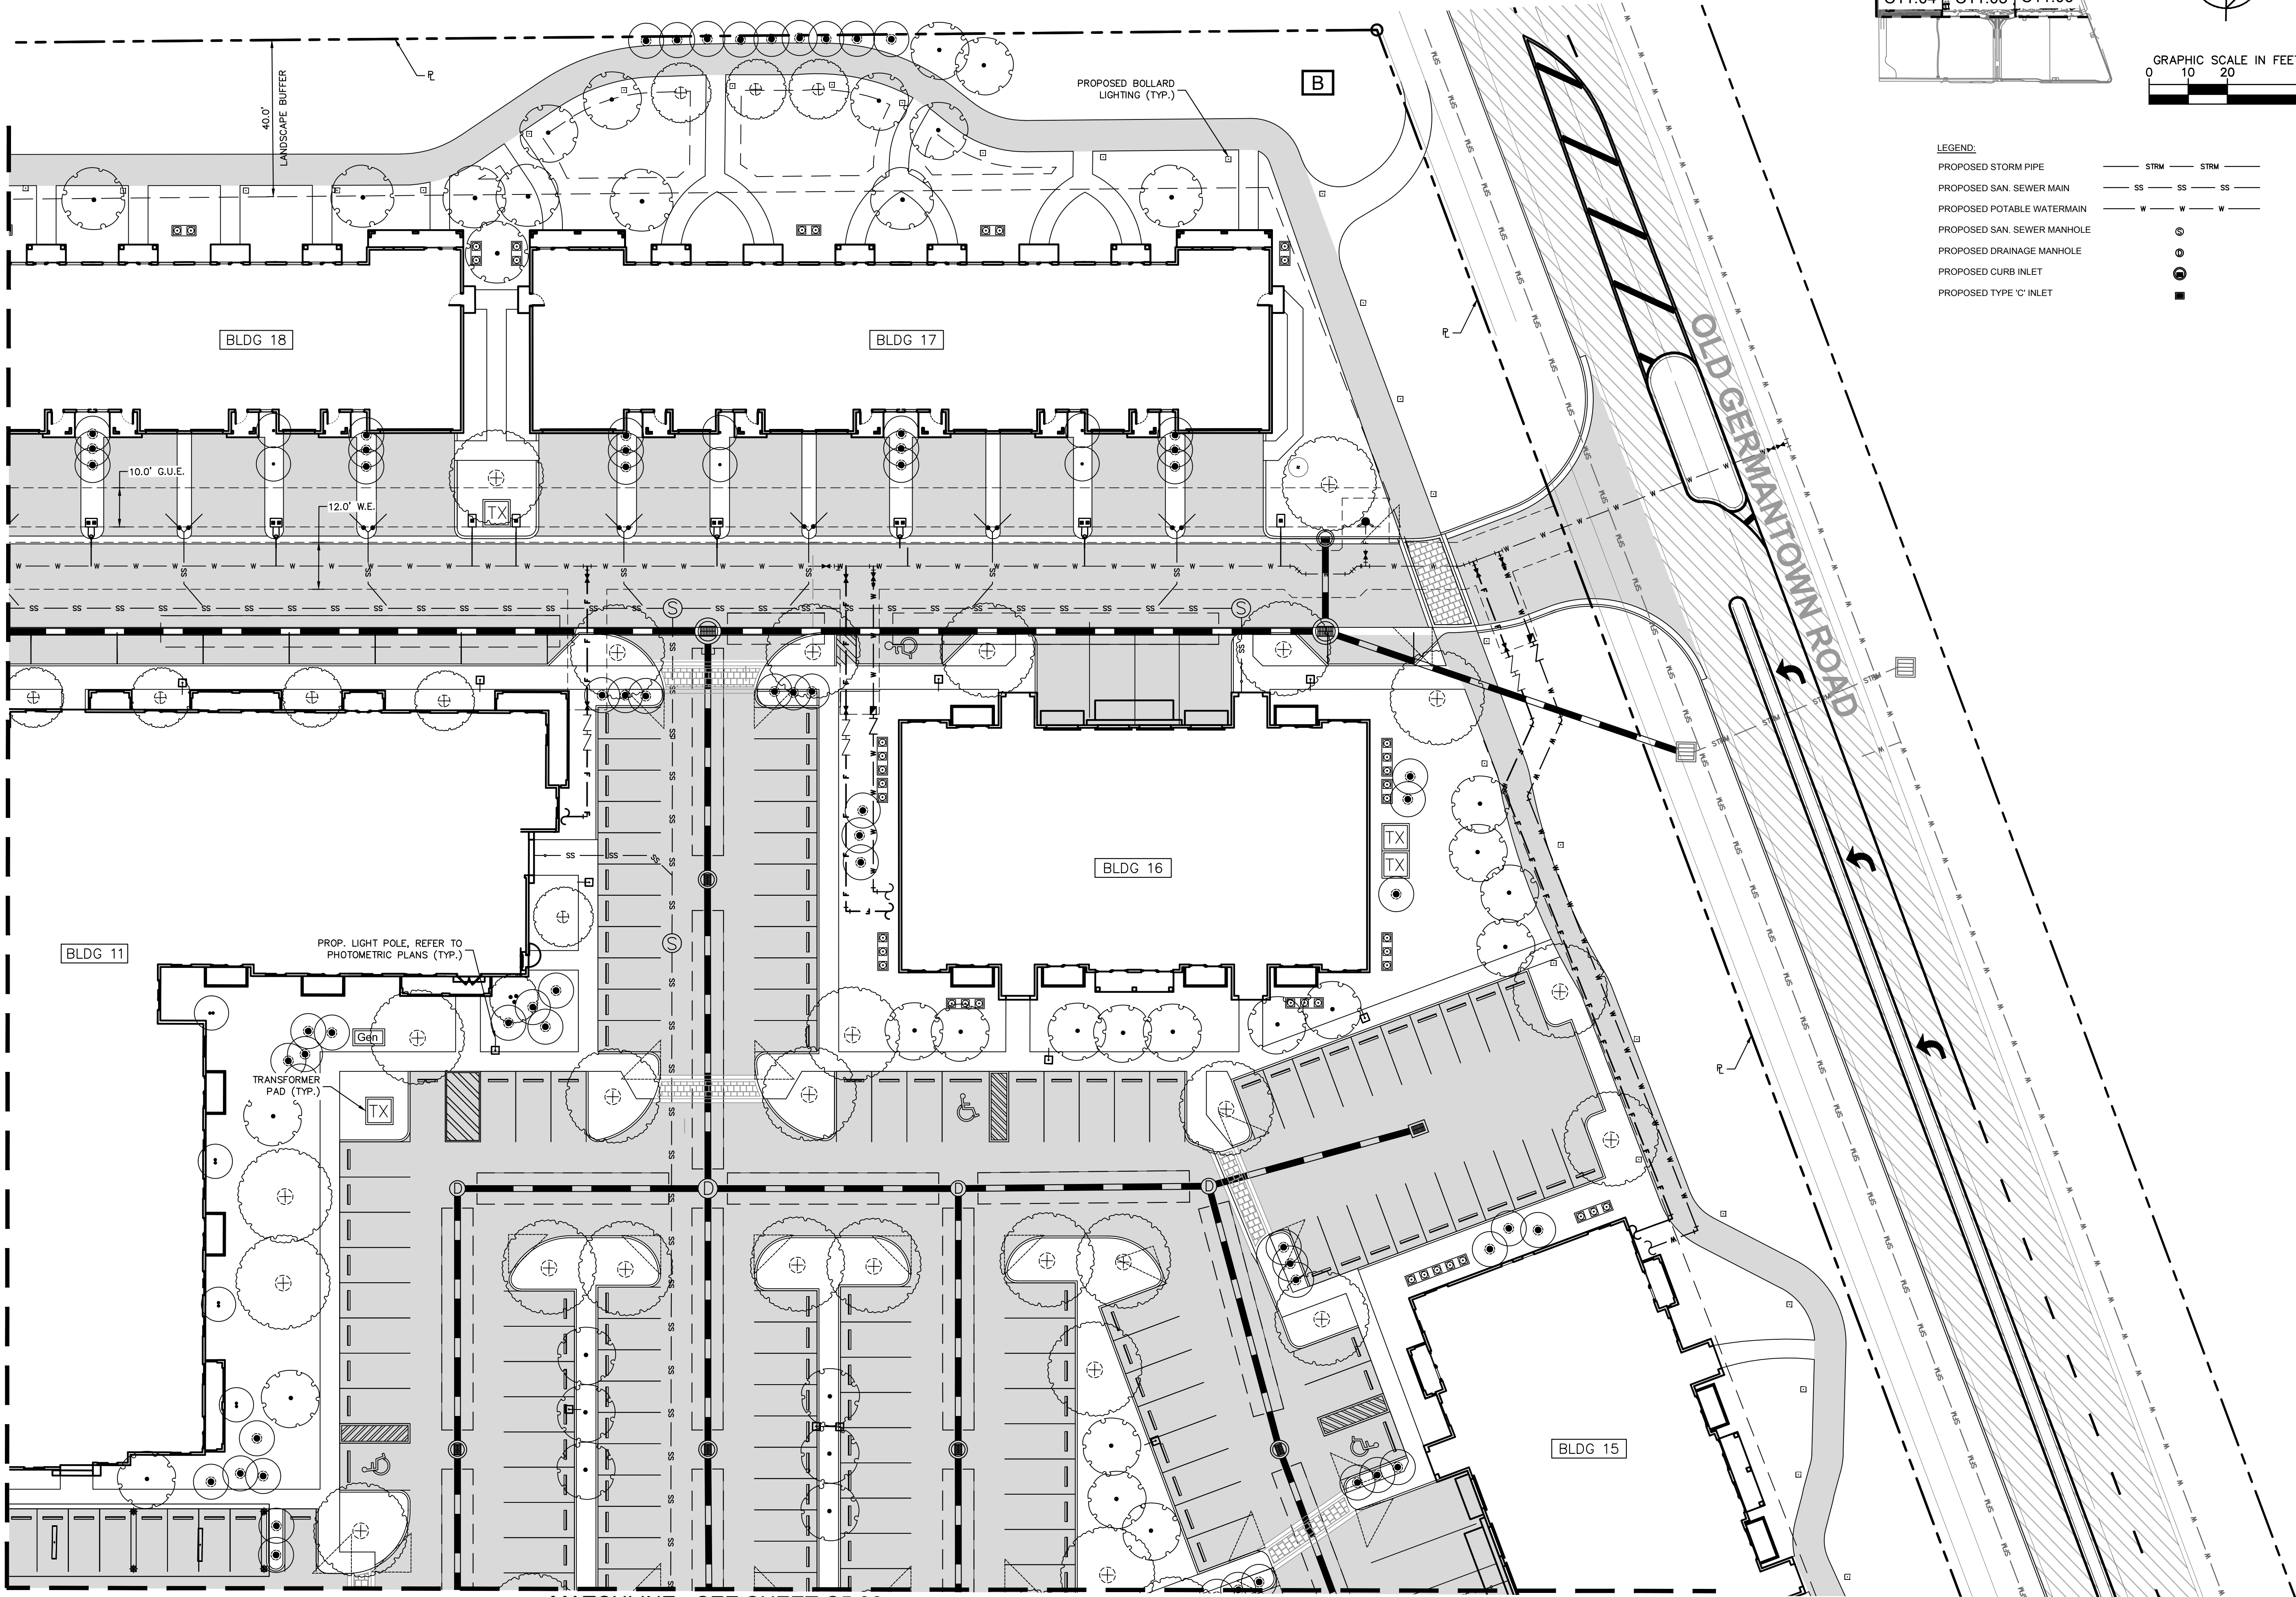


LEGEND:

- PROPOSED STORM PIPE
- PROPOSED SAN. SEWER MAIN
- PROPOSED POTABLE WATERMAIN
- PROPOSED SAN. SEWER MANHOLE
- PROPOSED DRAINAGE MANHOLE
- PROPOSED CURB INLET
- PROPOSED TYPE 'C' INLET

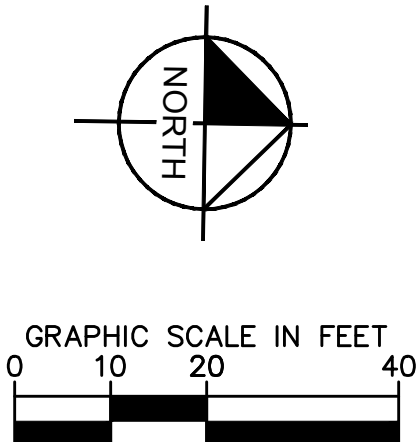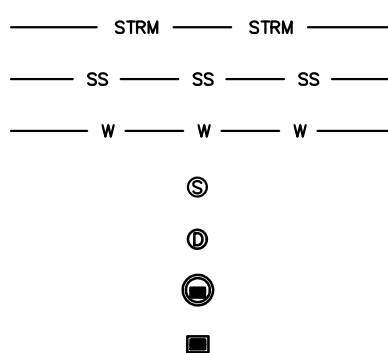


1690 - 2350 S. CONGRESS AVENUE PREPARED FOR 13TH FLOOR INVESTMENTS FLORIDA		COMPOSITE PLAN		KHA PROJECT 140248002 DATE NOV. 2020 SCALE AS SHOWN DESIGNED BY JVP DRAWN BY BJO CHECKED BY MDS		LICENSED PROFESSIONAL MICHAEL D. SPRUCE, P.E. FLORIDA LICENSE NUMBER 52776 DATE: _____		Kimley»Horn © 2020 KIMLEY-HORN AND ASSOCIATES, INC. 1615 S CONGRESS AVE., SUITE 201, DELRAY BEACH, FL 33445 PHONE: 561-330-2345 FAX: 561-863-8175 WWW.KIMLEY-HORN.COM CA 00000696		REVISIONS		BY DATE	
SHEET NUMBER C11.03													


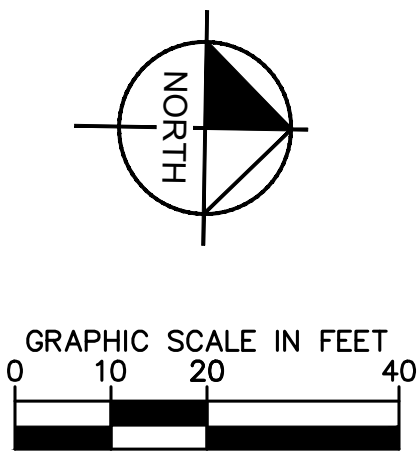


SHEET NUMBER		FLORIDA	
C11.04		DELRAY BEACH	
1690 - 2350 S.		13TH FLOOR INVESTMENTS	
CONGRESS AVENUE		PREPARED FOR	
COMPOSITE PLAN		FLORIDA	
KHA PROJECT 140248002		SCALE AS SHOWN	
DATE NOV 2020		DESIGNED BY JVP	
LICENSED PROFESSIONAL		DRAWN BY BUC	
MICHAEL D. SPRUCE, P.E.		CHECKED BY MDS	
FLORIDA LICENSE NUMBER 52776		DATE:	
© 2020 KIMLEY-HORN AND ASSOCIATES, INC. 1615 S CONGRESS AVE. SUITE 201, DELRAY BEACH, FL 33445 PHONE: 561-330-2345 FAX: 561-863-8175 WWW.KIMLEY-HORN.COM CA 00000696		Kimley»Horn	
		No.	
		REVISIONS	
		DATE	
		BY	

Plotted By: Sheil, Arie Sheet Set: 1690 - 2350 S. Congress Avenue Layout: C11.05 COMPOSITE PLAN November 03, 2020 11:35:59am K:\bcd-civil\140248002 - centrepoina\CADD\plansheets\C11.01 COMPOSITE PLAN.dwg This document, together with the concepts and designs presented herein, as an instrument of service, is intended only for the specific purpose and client for which it was prepared. Reuse of and improper reliance on this document without written authorization and adaptation by Kimley-Horn and Associates, Inc. shall be without liability to Kimley-Horn and Associates, Inc.

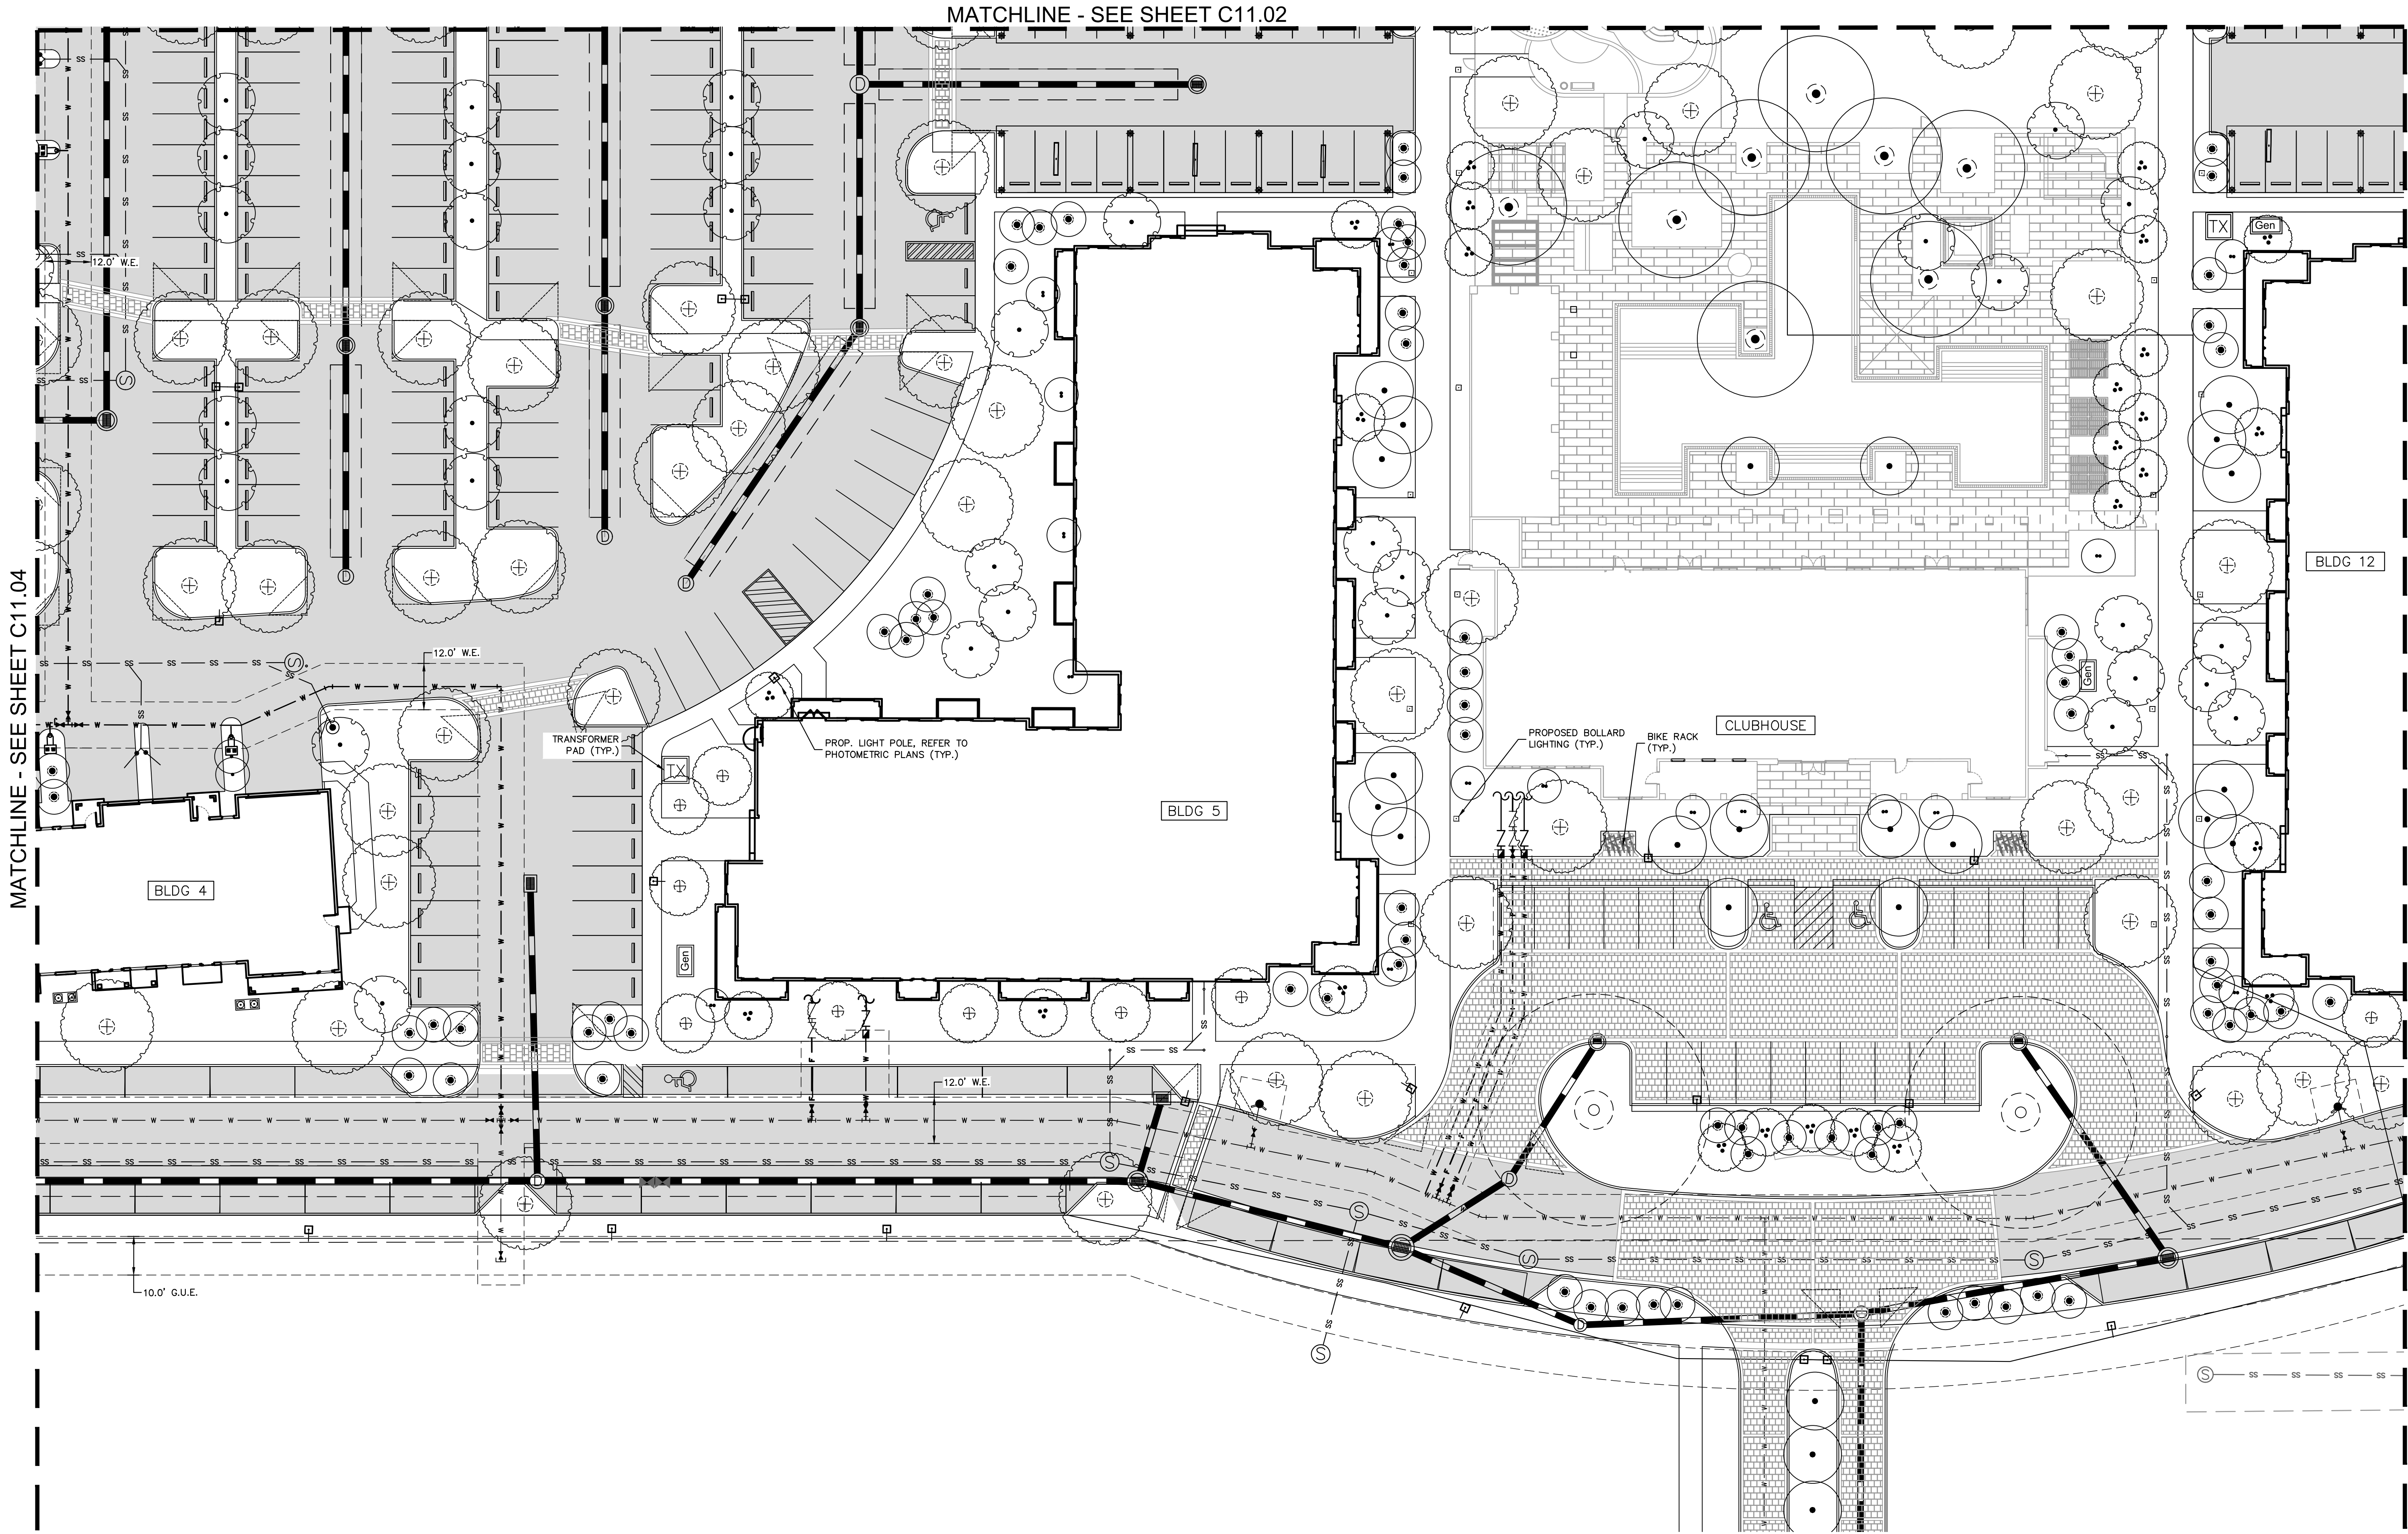

- LEGEND:
- PROPOSED STORM PIPE
 - PROPOSED SAN. SEWER MAIN
 - PROPOSED POTABLE WATERMAIN
 - PROPOSED SAN. SEWER MANHOLE
 - PROPOSED DRAINAGE MANHOLE
 - PROPOSED CURB INLET
 - PROPOSED TYPE 'C' INLET

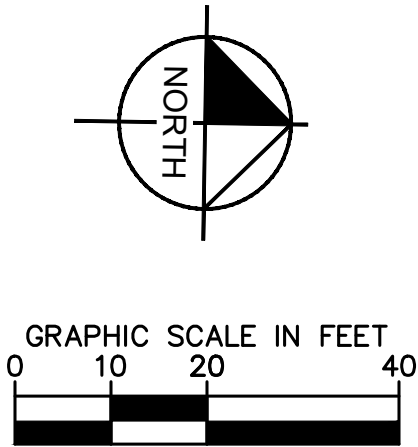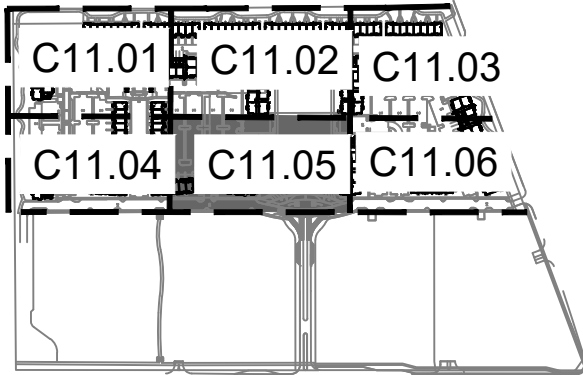


MATCHLINE - SEE SHEET C10.06

1690 - 2350 S. CONGRESS AVENUE PREPARED FOR 13TH FLOOR INVESTMENTS FLORIDA		COMPOSITE PLAN		KHA PROJECT 140248002		LICENSED PROFESSIONAL		Kimley»Horn		© 2020 KIMLEY-HORN AND ASSOCIATES, INC. 1615 S CONGRESS AVE, SUITE 201, DELRAY BEACH, FL 33445 PHONE: 561-330-2345 FAX: 561-863-8175 WWW.KIMLEY-HORN.COM CA 00000696	
SHEET NUMBER C11.05				DATE NOV. 2020		MICHAEL D. SPRUCE, P.E.					
				SCALE AS SHOWN		DESIGNED BY JVP		FLORIDA LICENSE NUMBER 52776			
				DRAWN BY B/J		CHECKED BY MDS		DATE: _____			
										REVISIONS	
										No.	
										DATE	
										BY	

Plotted By: Sheil, Arie Sheet: C11.06 - 2350 S. Congress Avenue Layout: C11.06 COMPOSITE PLAN November 03, 2020 11:39:18am K:\Voc-civil\140248002 - centrepoin\CADD\plansheets\C11.01 COMPOSITE PLAN.dwg

This document, together with the concepts and designs presented herein, as an instrument of service, is intended only for the specific purpose and client for which it was prepared. Reuse of and improper reliance on this document without written authorization and adaptation by Kimley-Horn and Associates, Inc. shall be without liability to Kimley-Horn and Associates, Inc.

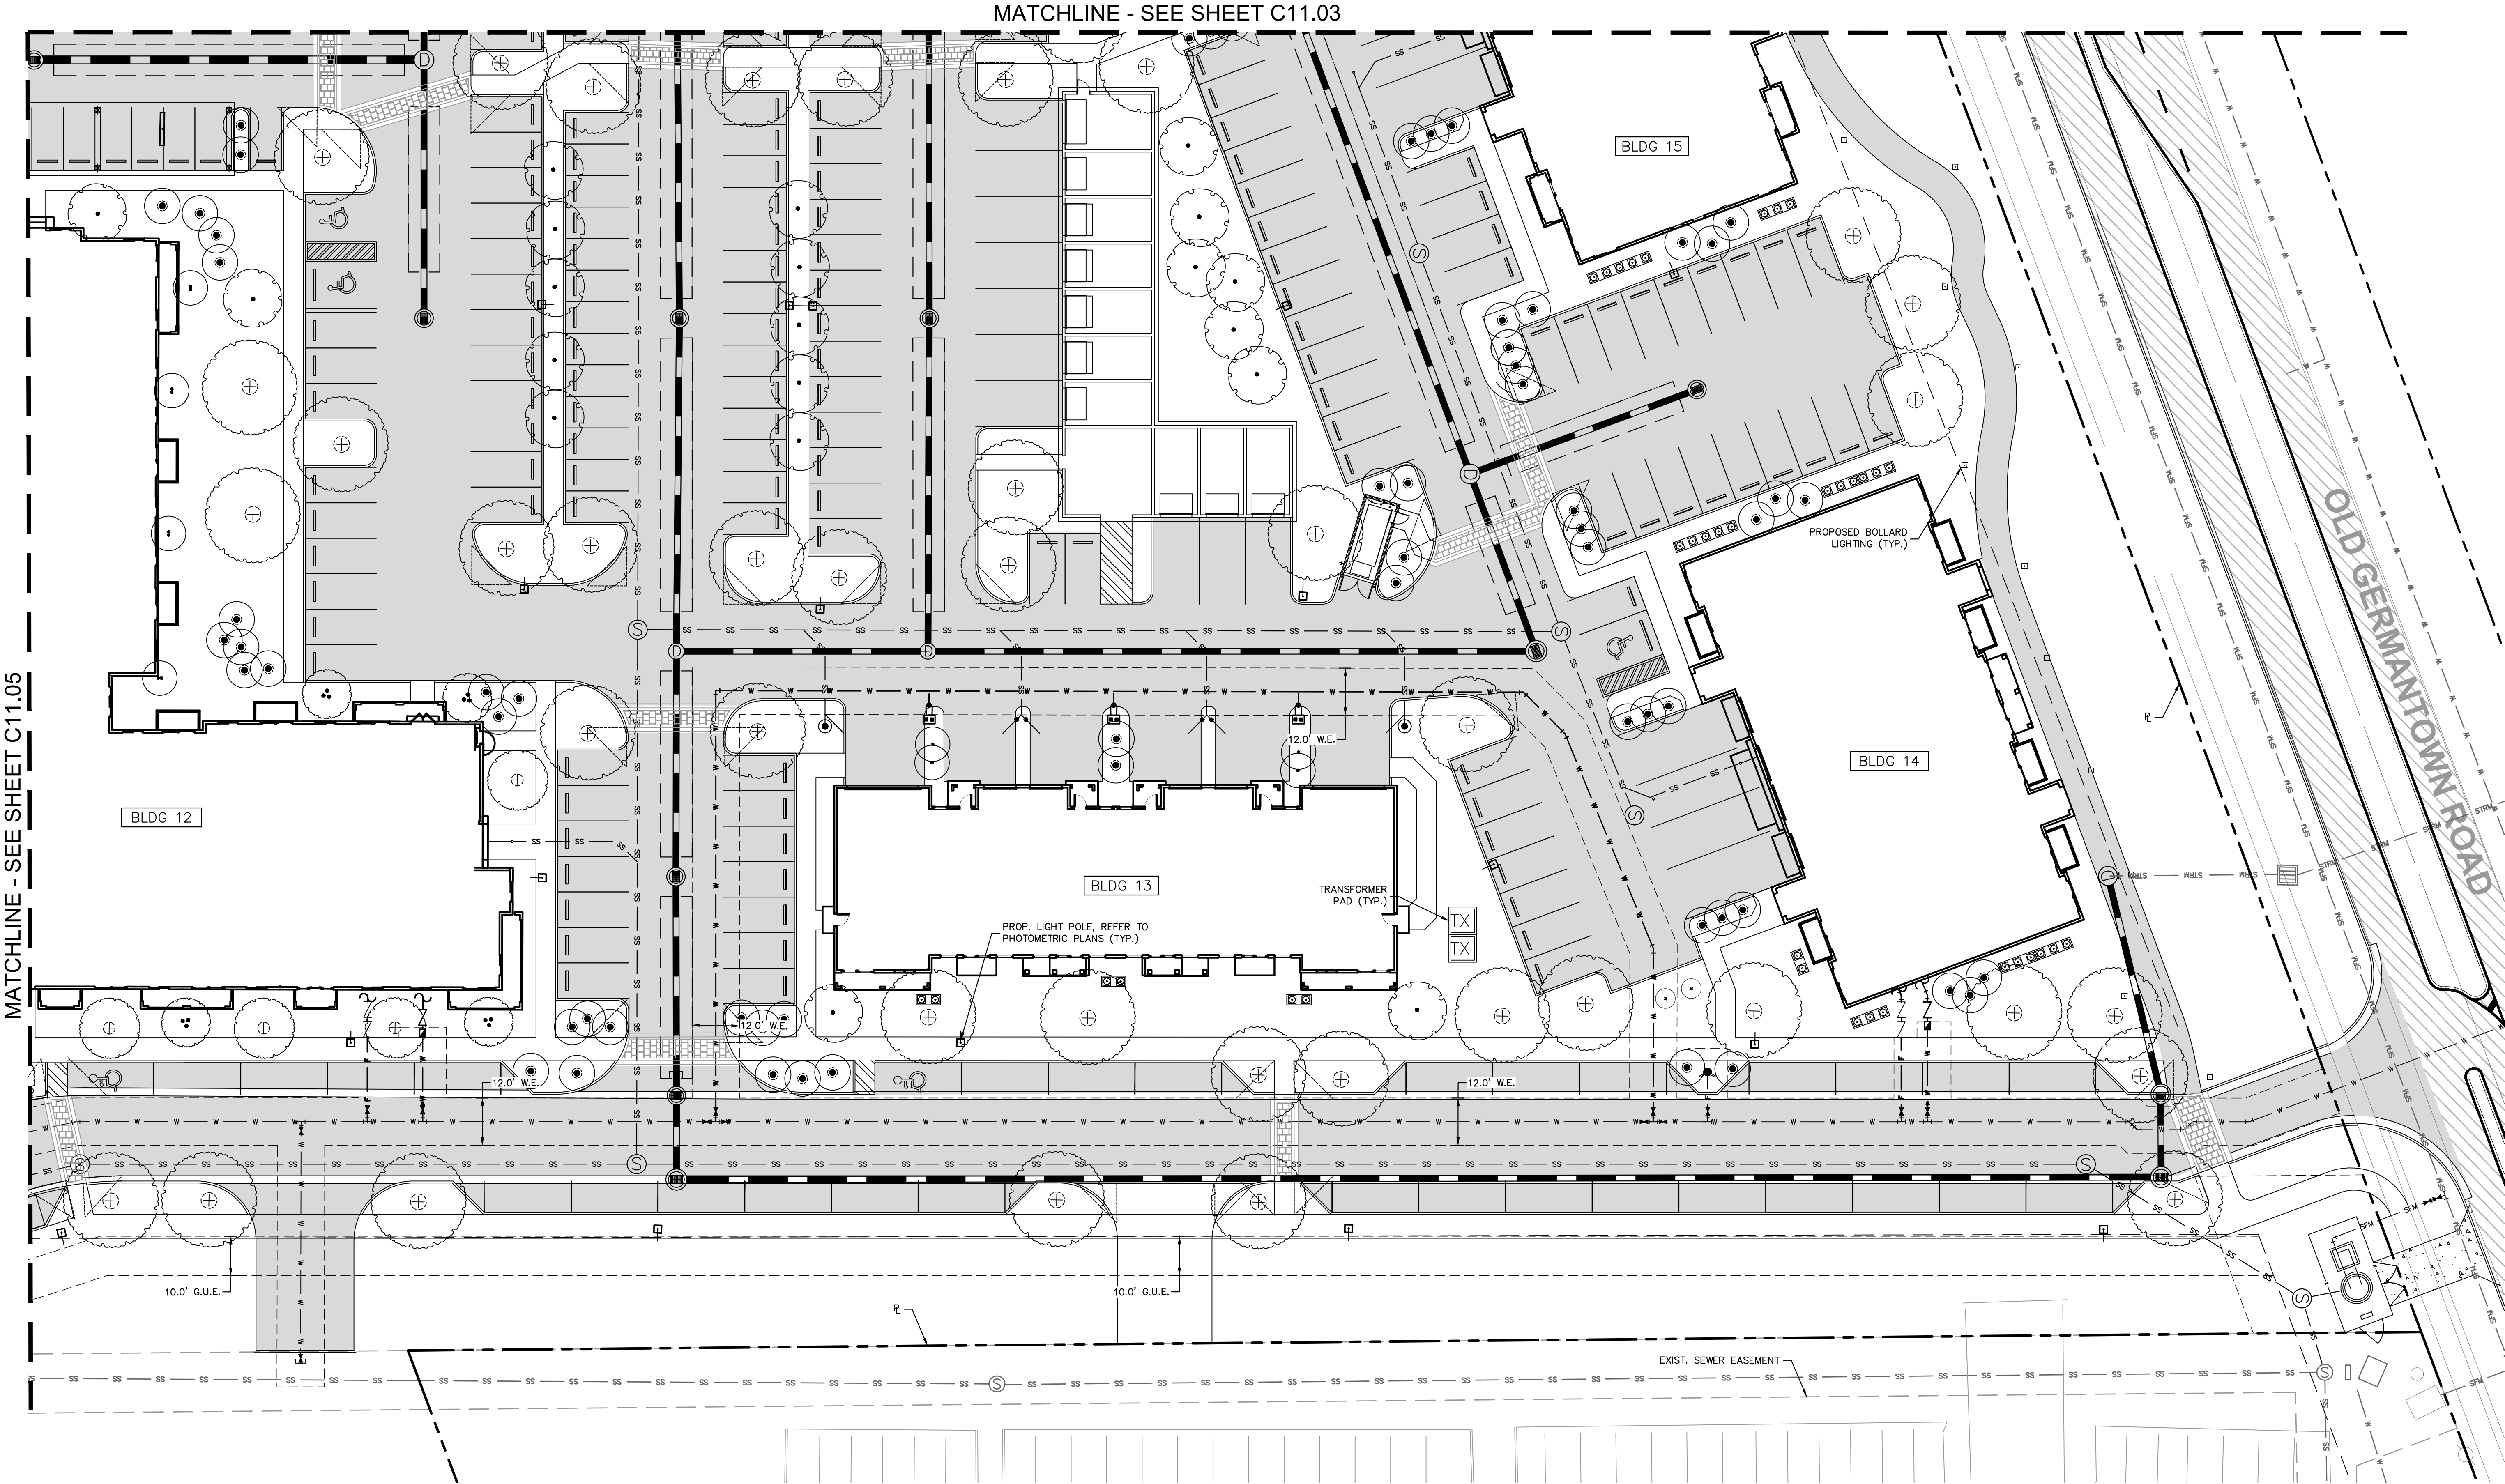

SHEET NUMBER		C11.06	
COMPOSITE PLAN		COMPOSITE PLAN	
1690 - 2350 S. CONGRESS AVENUE		1690 - 2350 S. CONGRESS AVENUE	
PREPARED FOR		PREPARED FOR	
13TH FLOOR INVESTMENTS		13TH FLOOR INVESTMENTS	
FLORIDA		FLORIDA	
DELRAY BEACH		DELRAY BEACH	
KHA PROJECT		KHA PROJECT	
140248002		140248002	
DATE		DATE	
NOV. 2020		NOV. 2020	
SCALE		SCALE	
AS SHOWN		AS SHOWN	
DESIGNED BY		DESIGNED BY	
JVP		JVP	
DRAWN BY		DRAWN BY	
B/J		B/J	
CHECKED BY		CHECKED BY	
MDS		MDS	
DATE		DATE	
---		---	
LICENSED PROFESSIONAL		LICENSED PROFESSIONAL	
MICHAEL D. SPRUCE, P.E.		MICHAEL D. SPRUCE, P.E.	
FLORIDA LICENSE NUMBER		FLORIDA LICENSE NUMBER	
52776		52776	
NO. OF SHEETS		NO. OF SHEETS	
1		1	
DATE		DATE	
---		---	
BY		BY	
---		---	
REVISIONS		REVISIONS	
No.		No.	
---		---	
DATE		DATE	
---		---	
BY		BY	
---		---	
Kimley»Horn		Kimley»Horn	
© 2020 KIMLEY-HORN AND ASSOCIATES, INC.		© 2020 KIMLEY-HORN AND ASSOCIATES, INC.	
1615 S CONGRESS AVE, SUITE 201, DELRAY BEACH, FL 33445		1615 S CONGRESS AVE, SUITE 201, DELRAY BEACH, FL 33445	
PHONE: 561-330-2345 FAX: 561-863-8175		PHONE: 561-330-2345 FAX: 561-863-8175	
WWW.KIMLEY-HORN.COM CA 0000696		WWW.KIMLEY-HORN.COM CA 0000696	