



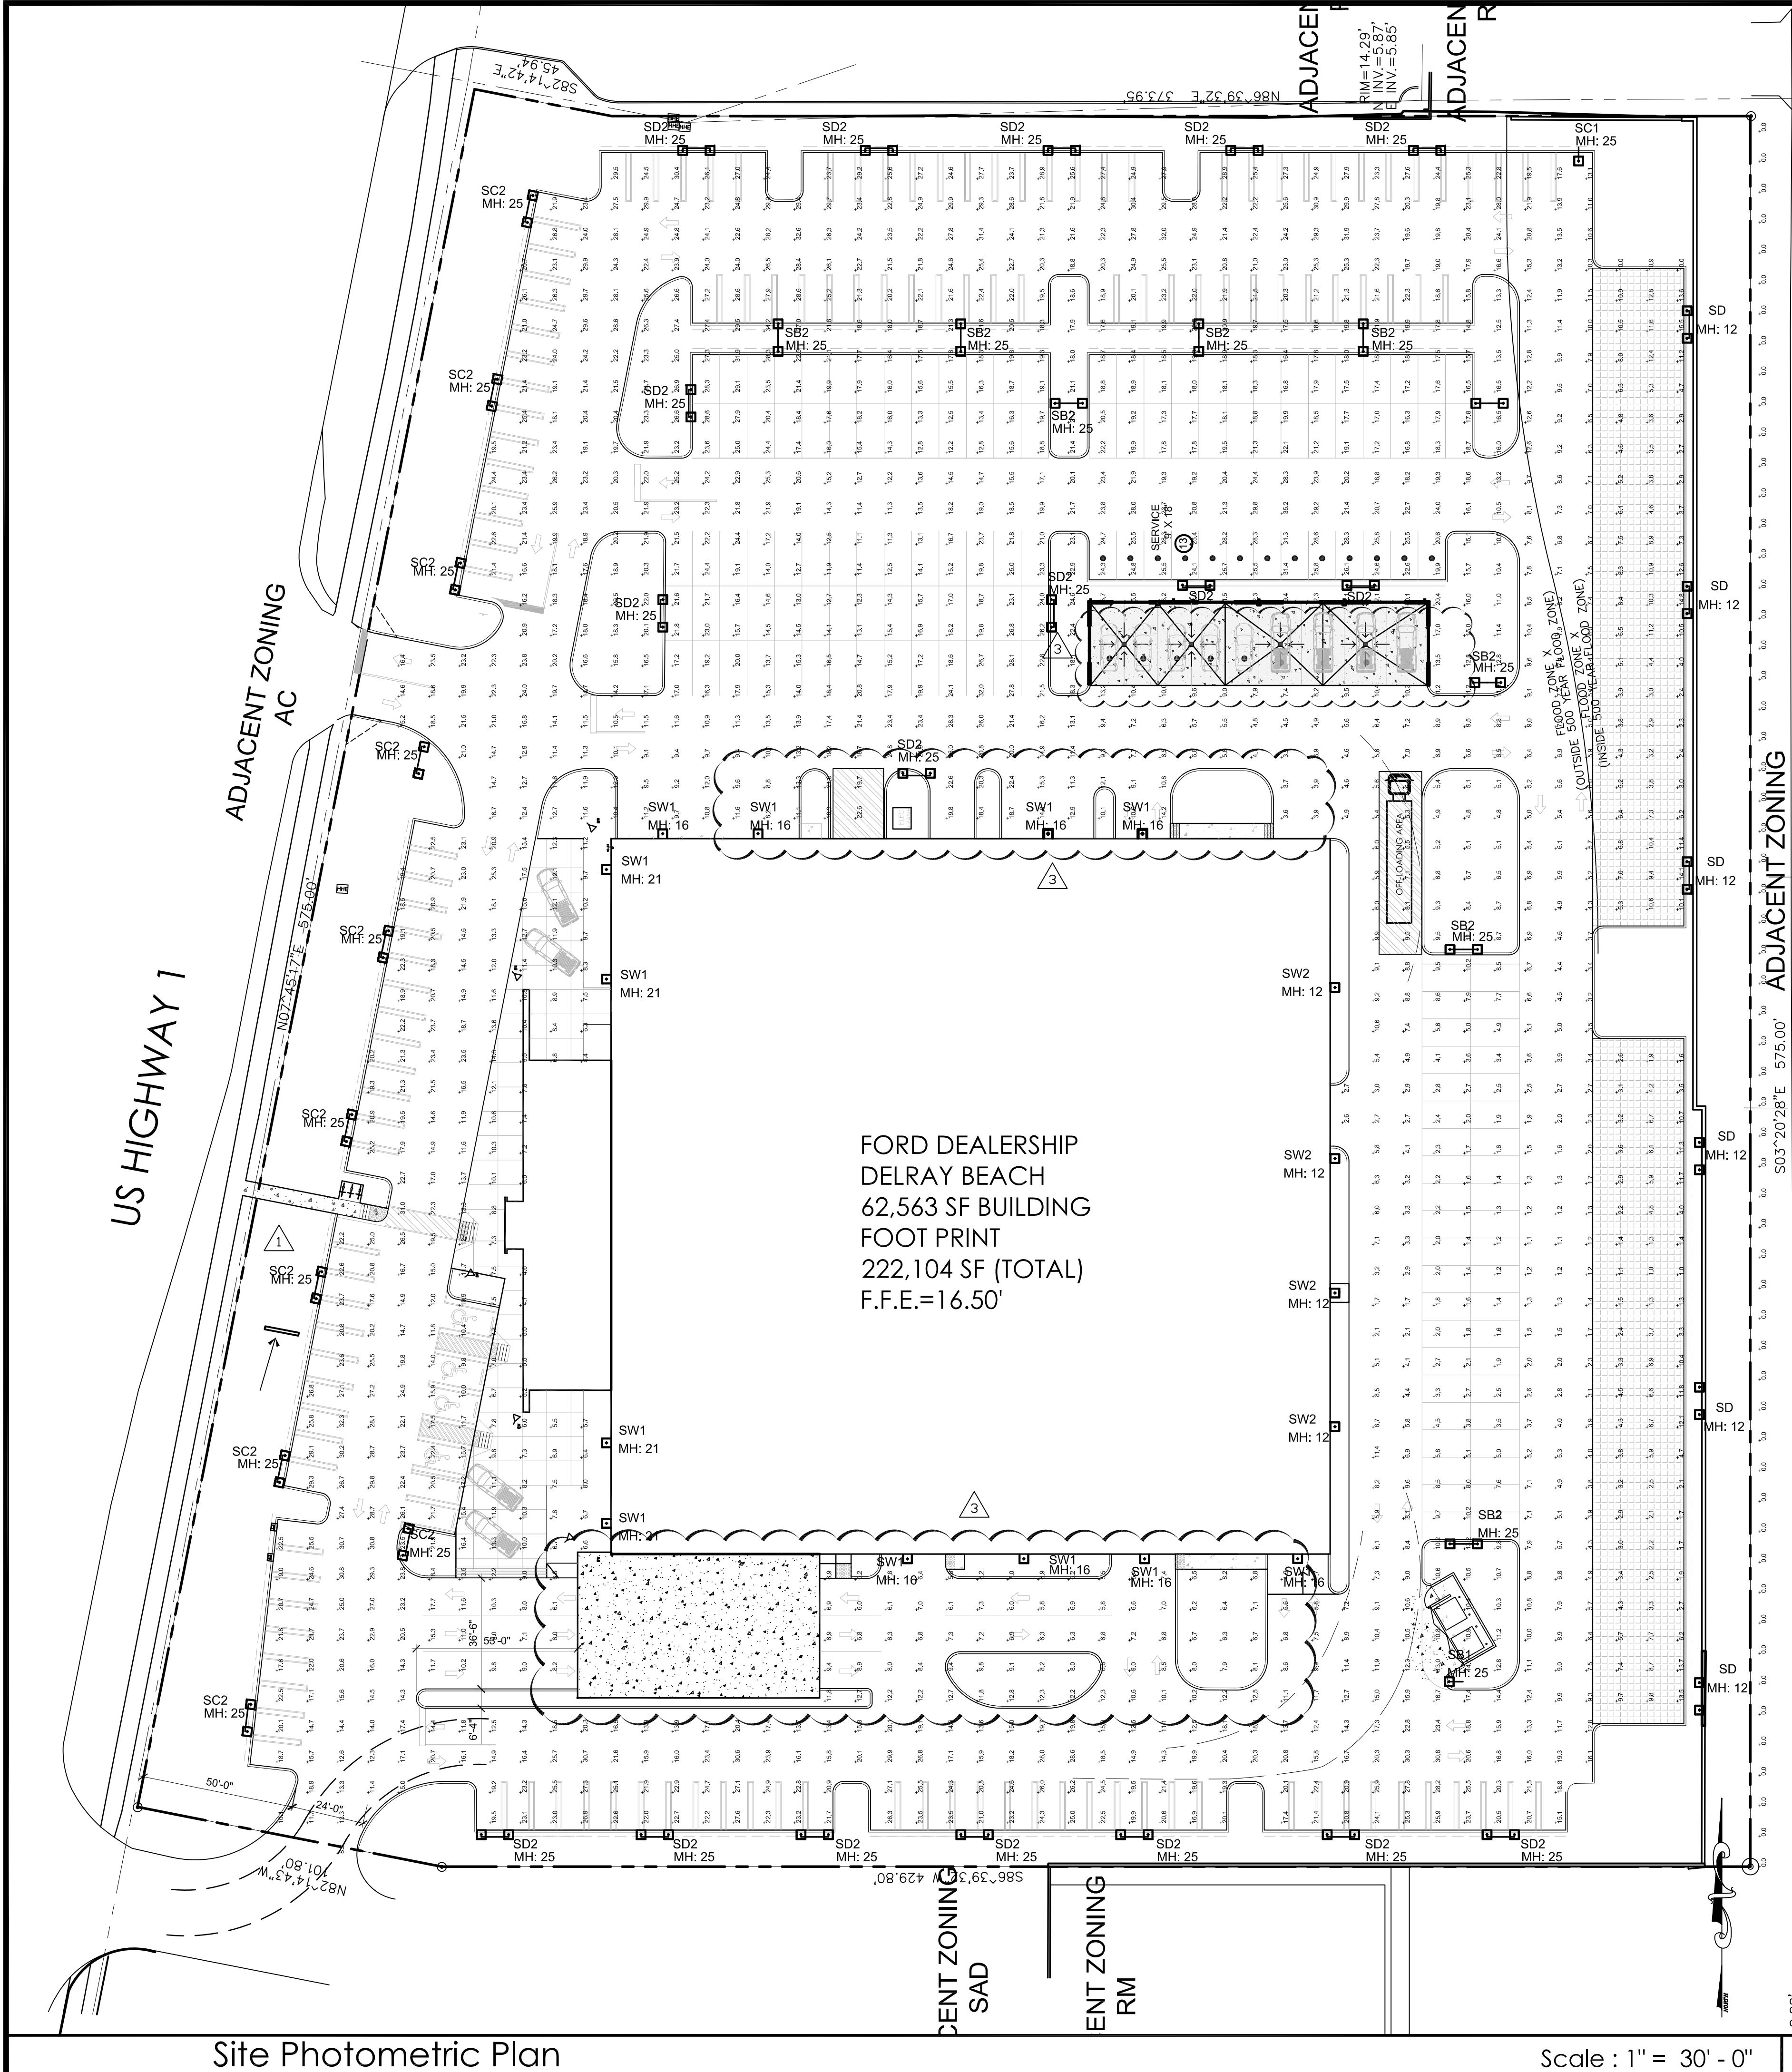


Site Photometric Plan

Scale : 1" = 30' - 0"

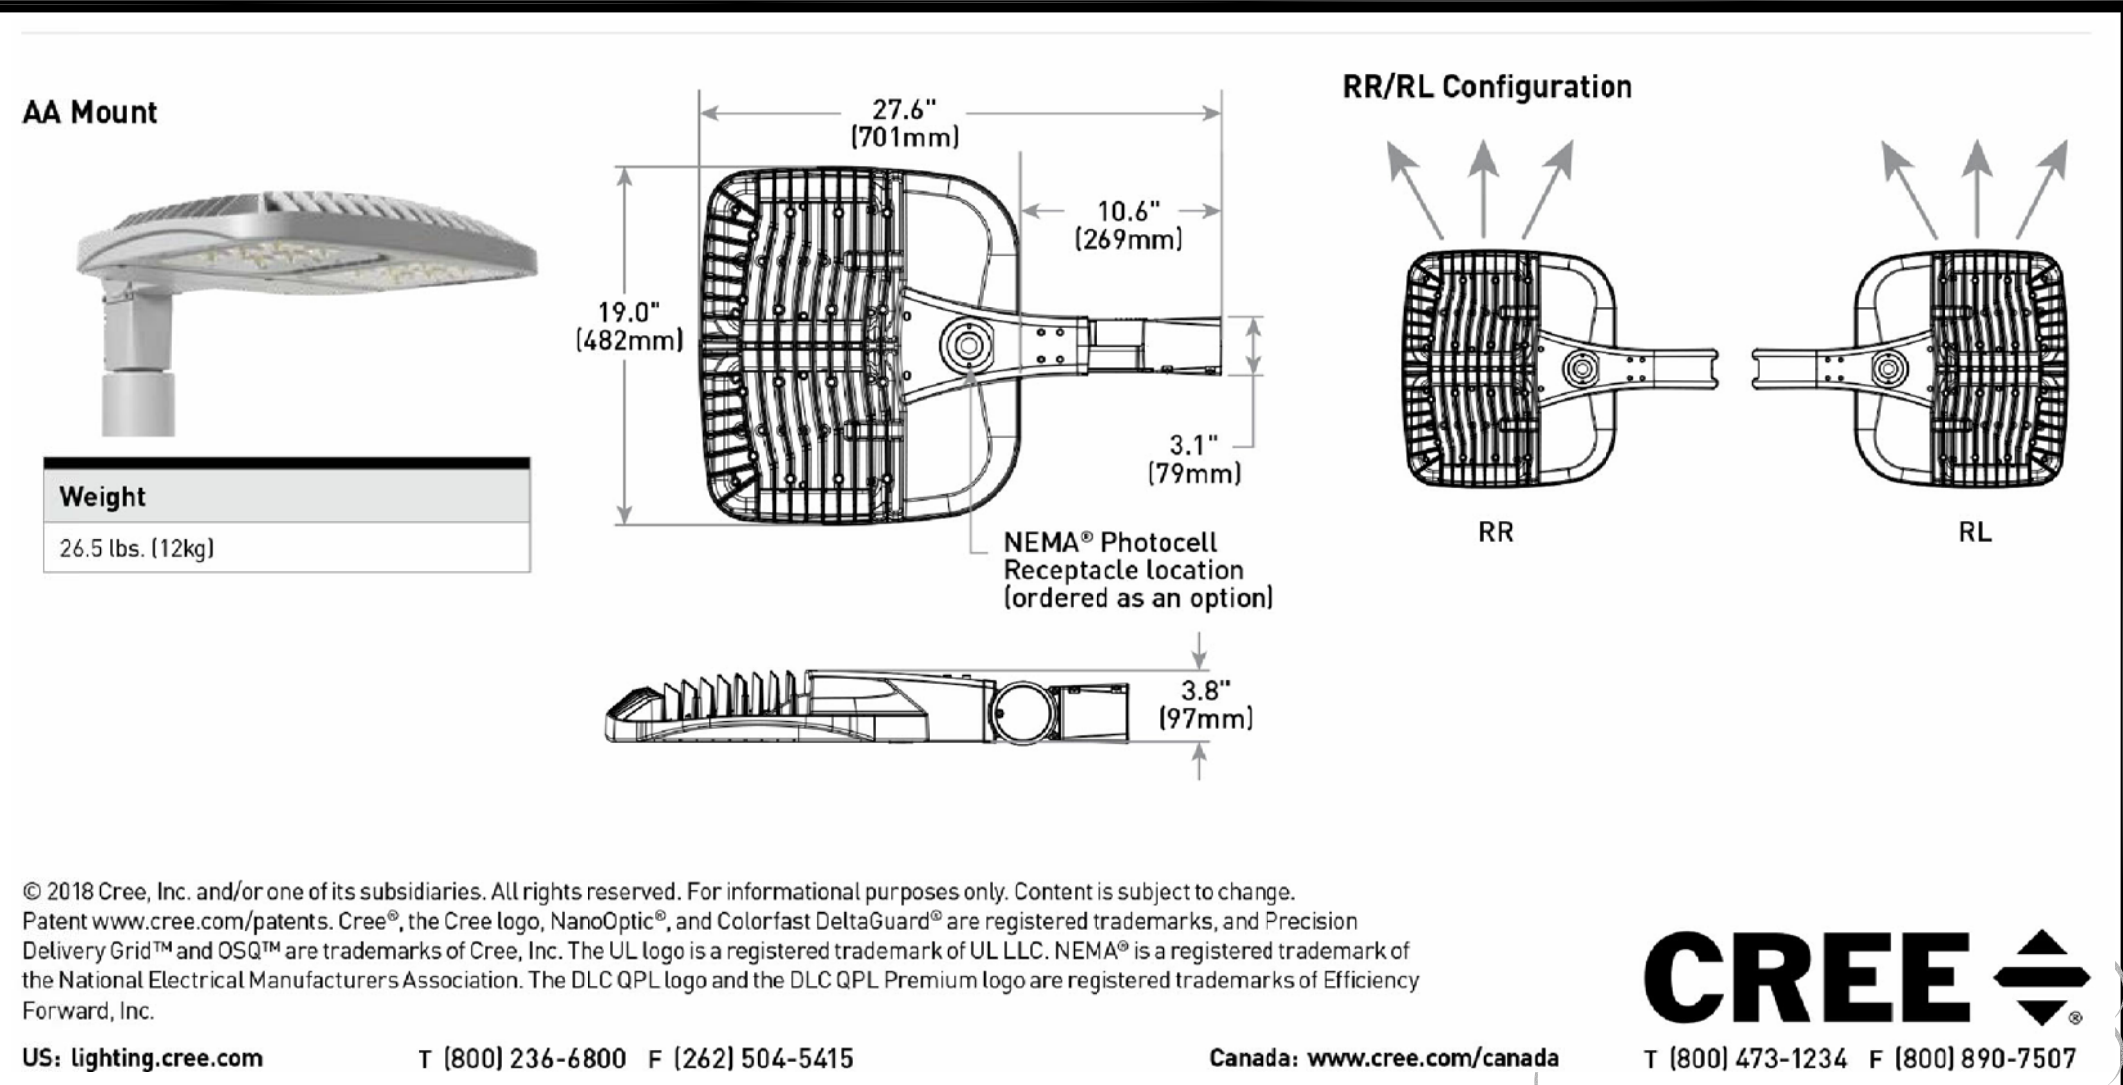

Site Lighting Fixture Detail

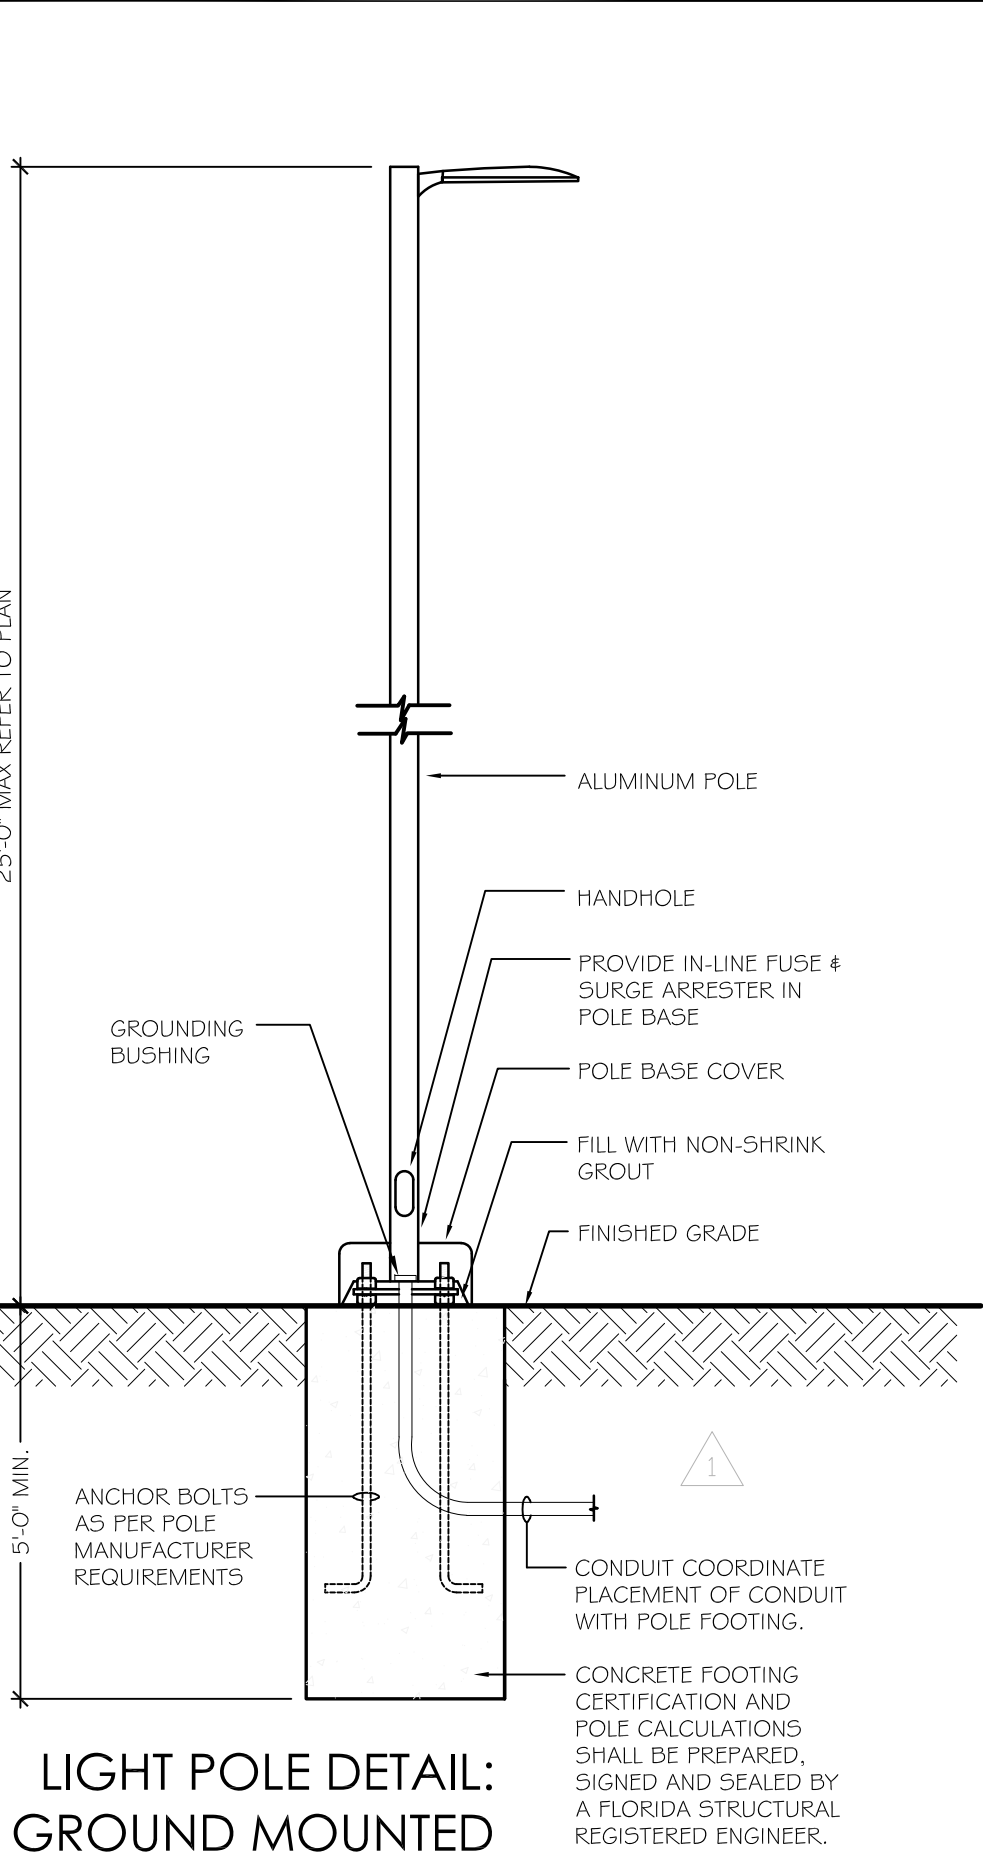

LIGHT POLE DETAIL: GROUND MOUNTED

Luminaire Schedule		LLF		Lum. Watts		Lum. Lumens	
Symbol	Qty	Label	Description				
9	SB1		CREE LTGF: OSQ-HO-A-5ME-40L-40K-UL / MTG HEIGHT PER PLAN	0.900	345.35	39153	
9	SB2		CREE LTGF: (2) OSQ-HO-A-5ME-40L-40K-UL / MTG HEIGHT PER PLAN	0.900	345.35	39153	
1	SC1		CREE LTGF: OSQ-HO-A-4ME-50L-40K-UL / MTG HEIGHT PER PLAN	0.900	420	51571	
10	SC2		CREE LTGF: (2) OSQ-HO-A-4ME-50L-40K-UL / MTG HEIGHT PER PLAN	0.900	420	51571	
6	SD		CREE LTGF: (2) OSQ-A-4ME-240K-UL / MTG HEIGHT PER PLAN	0.900	53	6896	
18	SD2		CREE LTGF: (2) OSQ-HO-A-4ME-50L-40K-UL / MTG HEIGHT PER PLAN	0.900	420	51571	
14	SW1		CREE LTGF: SEC-EDG-4M-06-E-UL-700-40K / WALL MTD PER PLAN	0.900	132.1	11607	
3	SW2		CREE LTGF: SEC-EDG-4M-06-E-UL-700-40K / WALL MTD PER PLAN	0.980	132.1	11607	

Luminaire Schedule

Calculation Summary		CalcType		Units		Avg		Max		Min		Avg/Min		Max/Min	
Label															
PARKING AREAS						Fc	14.83	35.2	1.0	14.83	35.20				
SPILL LIGHT						Fc	0.00	0.0	0.0	N/A	N/A				
DISPLAY FRONT						Fc	20.60	25.2	17.9	1.15	1.41				

Calc. Summary

NOTE: SITE ILLUMINATION WILL BE REDUCED TO LESS THAN 50 FC AFTER 9:00 PM PER SECTION 4.4.10.G.6.C

Site Lighting Detail and Schedules

CONSULTANT

STATE OF FLORIDA
REGISTERED ARCHITECT

Gregory B. Molina
FL REG. # AR 93354
DATE: 12-29-18

Copyright © 2019
All rights reserved. This document
contains confidential information and may not be
reproduced in any form without
written consent from GBM Architecture PA.

GBM
ARCHITECTURE PA

ARCHITECTURE
MASTER PLANNING
A26002322

2801 SW 3RD AVENUE, UNIT F8
FORT LAUDERDALE, FLORIDA 33315
T: 954.713.6101
C: 954.812.6680
E: GREG@GBMARCHITECTURE.COM
WEB: WWW.GBMARCHITECTURE.COM

DELAY BEACH FORD
2501 SOUTH FEDERAL HIGHWAY
DELAIR BEACH, FL 33483

PALM BEACH COUNTY
CITY OF DELAIR BEACH

DRAWING ISSUE DATES:

1 01-19-18: CITY COMMENTS
2 12-29-18: BLDG. REV
3 4-1-20 BLDG. REV

SITE PLAN
PHOTOMETRIC

SHEET
PH-1

PROJECT 161020
DATE 12-29-18
PERMIT NO.