


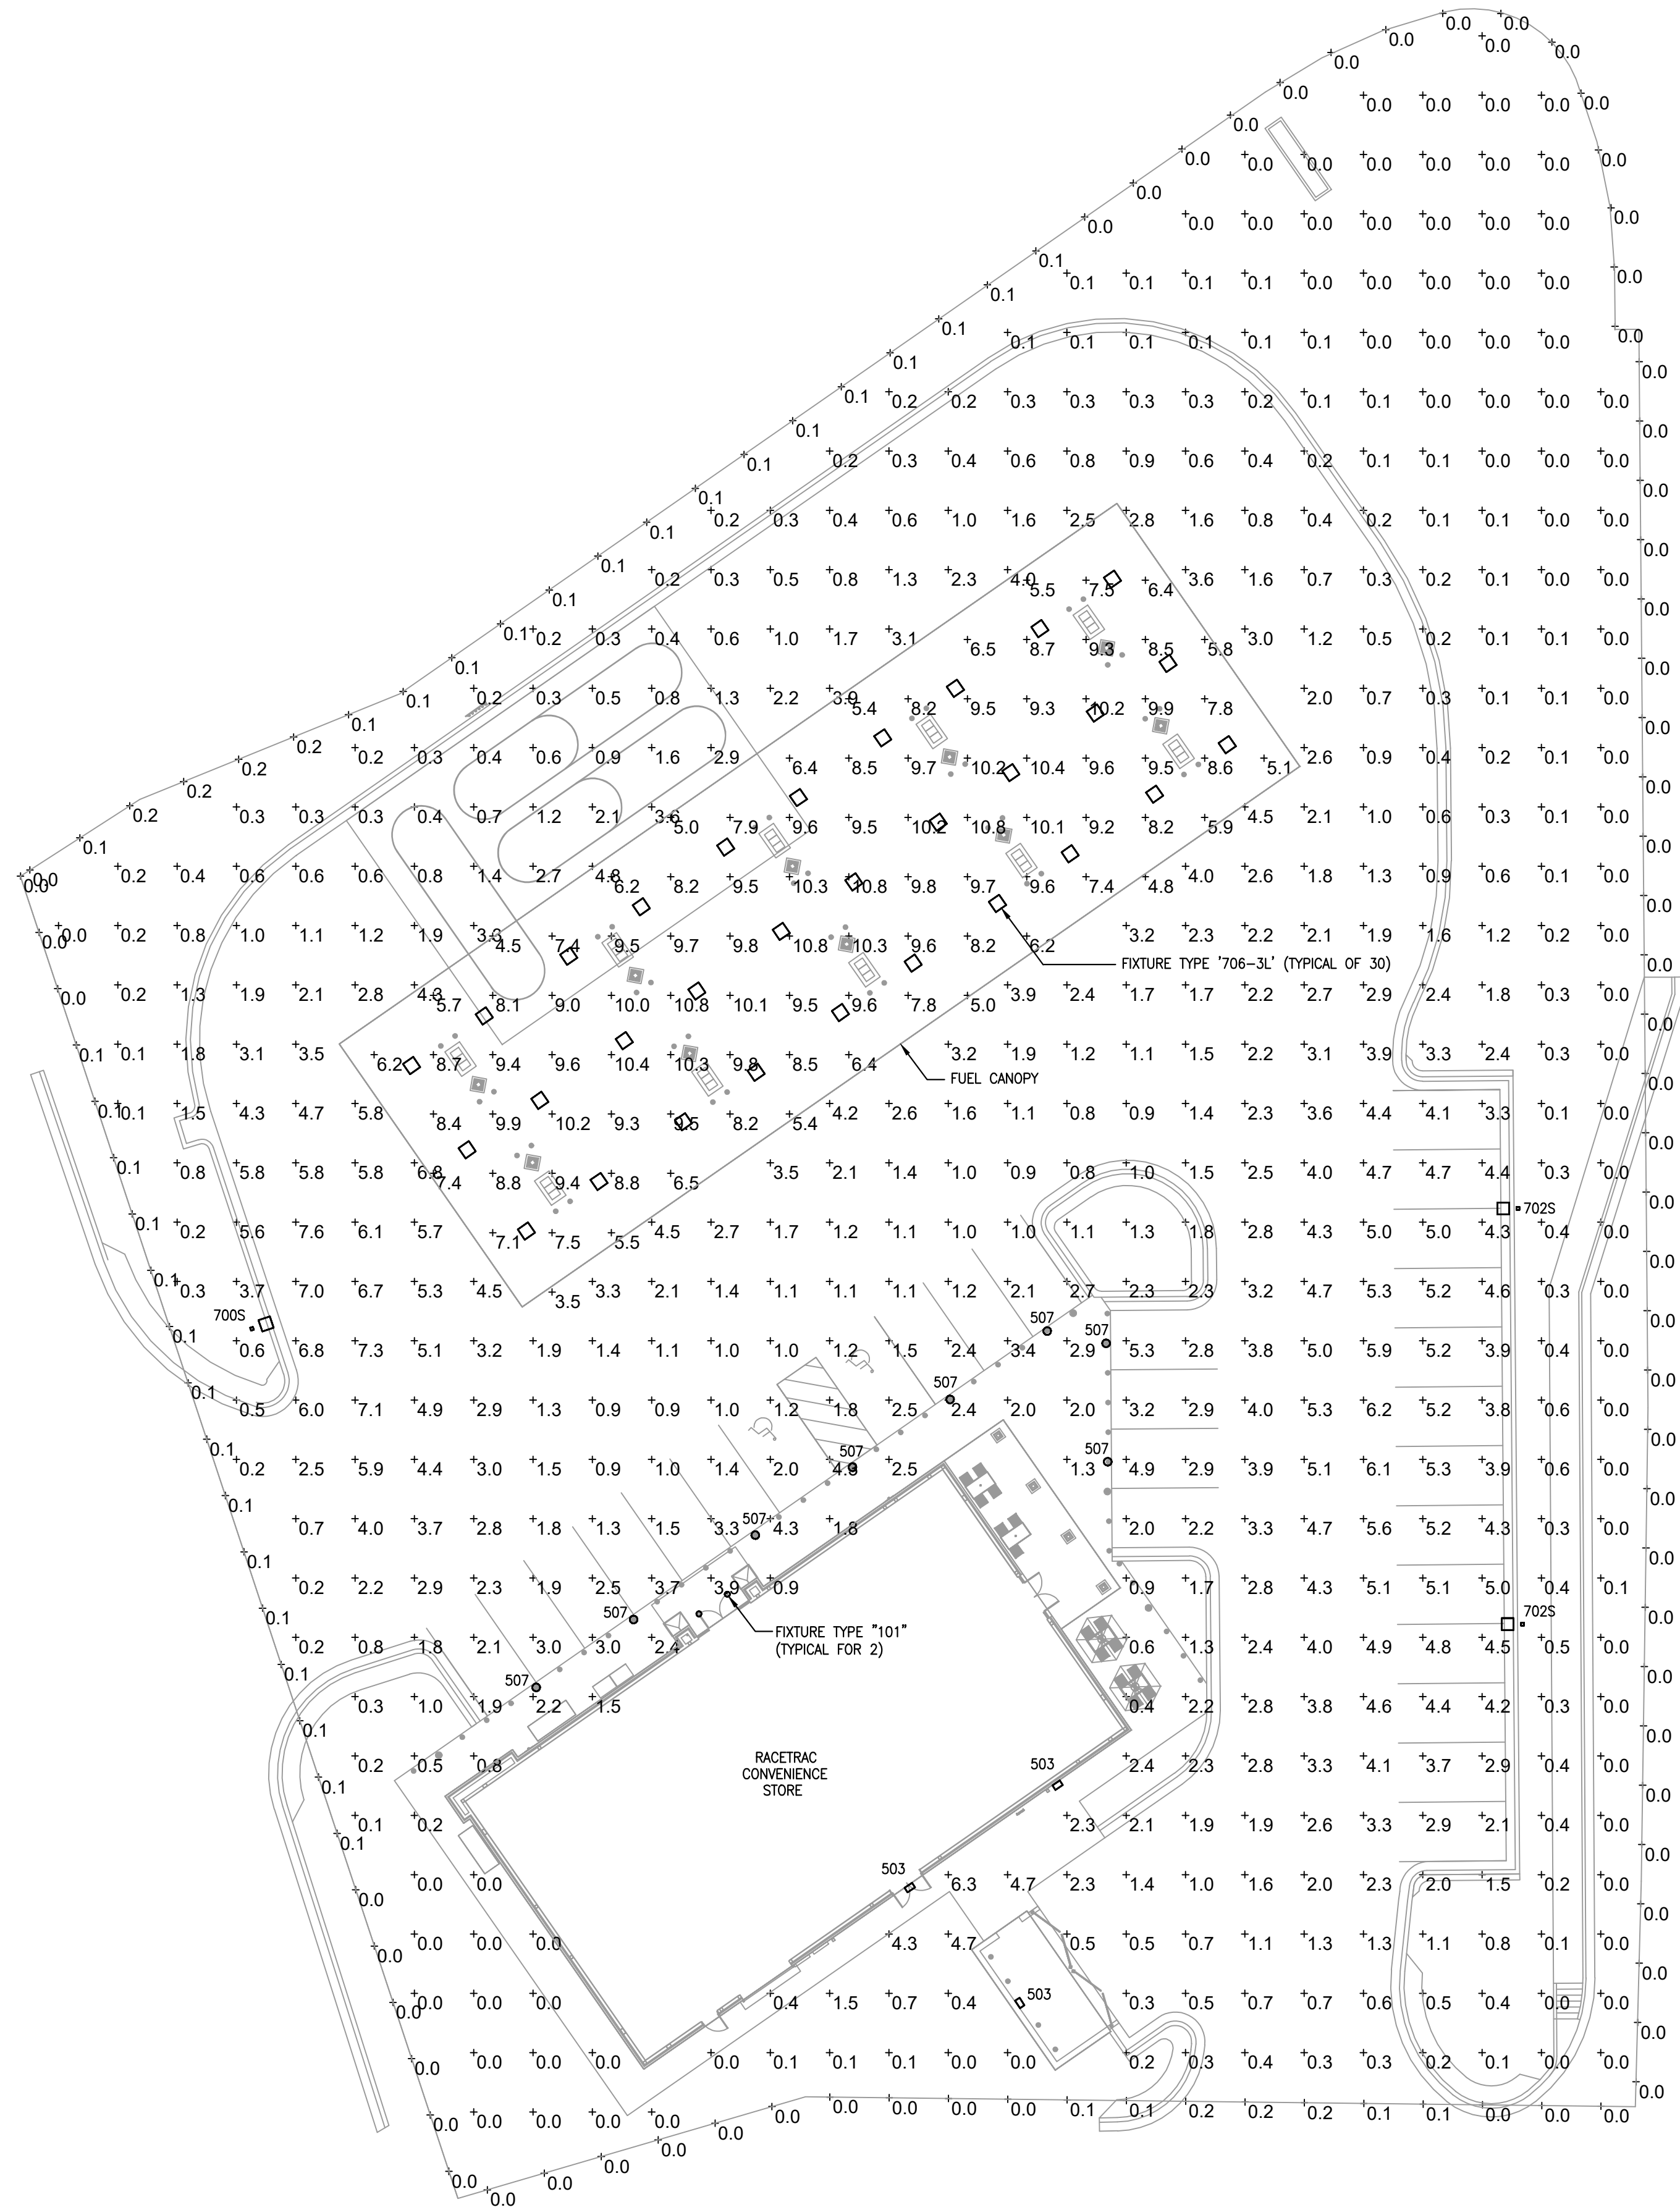

1 SITE PHOTOMETRY PLAN
SP-1 SCALE: 1" = 20'-0"

GENERAL NOTES

- ALL LIGHTS USED ON THIS PHOTOMETRY PLAN ARE RATED FULL CUTOFF.
- MOUNT AREA LUMINAIRE TYPES '700S' & '702S' AT 25'-0" AFG (INCLUDING POLE BASE).

STATISTICS

Description	Symbol	Avg	Max	Min	Max/Min	Avg/Min
Property Line	+	0.0 fc	0.2 fc	0.0 fc	N / A	N / A
Fuel Canopy	+	8.4 fc	10.8 fc	3.5 fc	3.1:1	2.4:1
Site	+	1.7 fc	7.6 fc	0.0 fc	N / A	N / A

LUMINAIRE SCHEDULE

Symbol	Label	Qty	Catalog Number	Description	Lamp	Mounting Height	File	Lumens	LLF	Watts
□	706-3L	30	WCP-03L-DA W-50	LED CANOPY LIGHT	LIGHT EMITTING DIODES	16'-0" AFG	WCP-03L-DA W-50LES	3481	0.90	29
○	101	2	A2/B1-05	WITH WHITE TRIM & RECESSED WHITE PLASTIC LENS	LEDS LUMEN = 648 LMS.	12'-0" AFG	LRL101	647	0.90	11.5
○	507	8	SP2-STR-Y4-2050 -FCO-MOD/086-12 LED-DB	SPECTRA FIXTURE	12 LED ARRAY	12'-0" AFG	SP2-STR-Y4-2050 -FCO-MOD/086-12 LED-DBLES	2047	0.90	27.3
□ D	700S	1	MRW-LED-30L-SIL 2-700R-L	LED AREA LIGHT WITH BACKLIGHT CONTROL	LIGHT EMITTING DIODES	25'-0" AFG	MRW-LED-30L- SIL-2-700R- -LLES	19798	0.90	247
□ D	702S	2	MRW-LED-30L-SIL FT-700R-L	LED AREA LIGHT WITH BACKLIGHT CONTROL	LIGHT EMITTING DIODES	25'-0" AFG	MRW-LED-30L- SIL-FT-700R- -LLES	20683	0.90	247
□	503	3	XMM-2-LED- 03-50	LED WALL PACK	LIGHT EMITTING DIODES	14'-0" AFG	XMM-2-LED- 03-50LES	3456	0.90	28.2

