


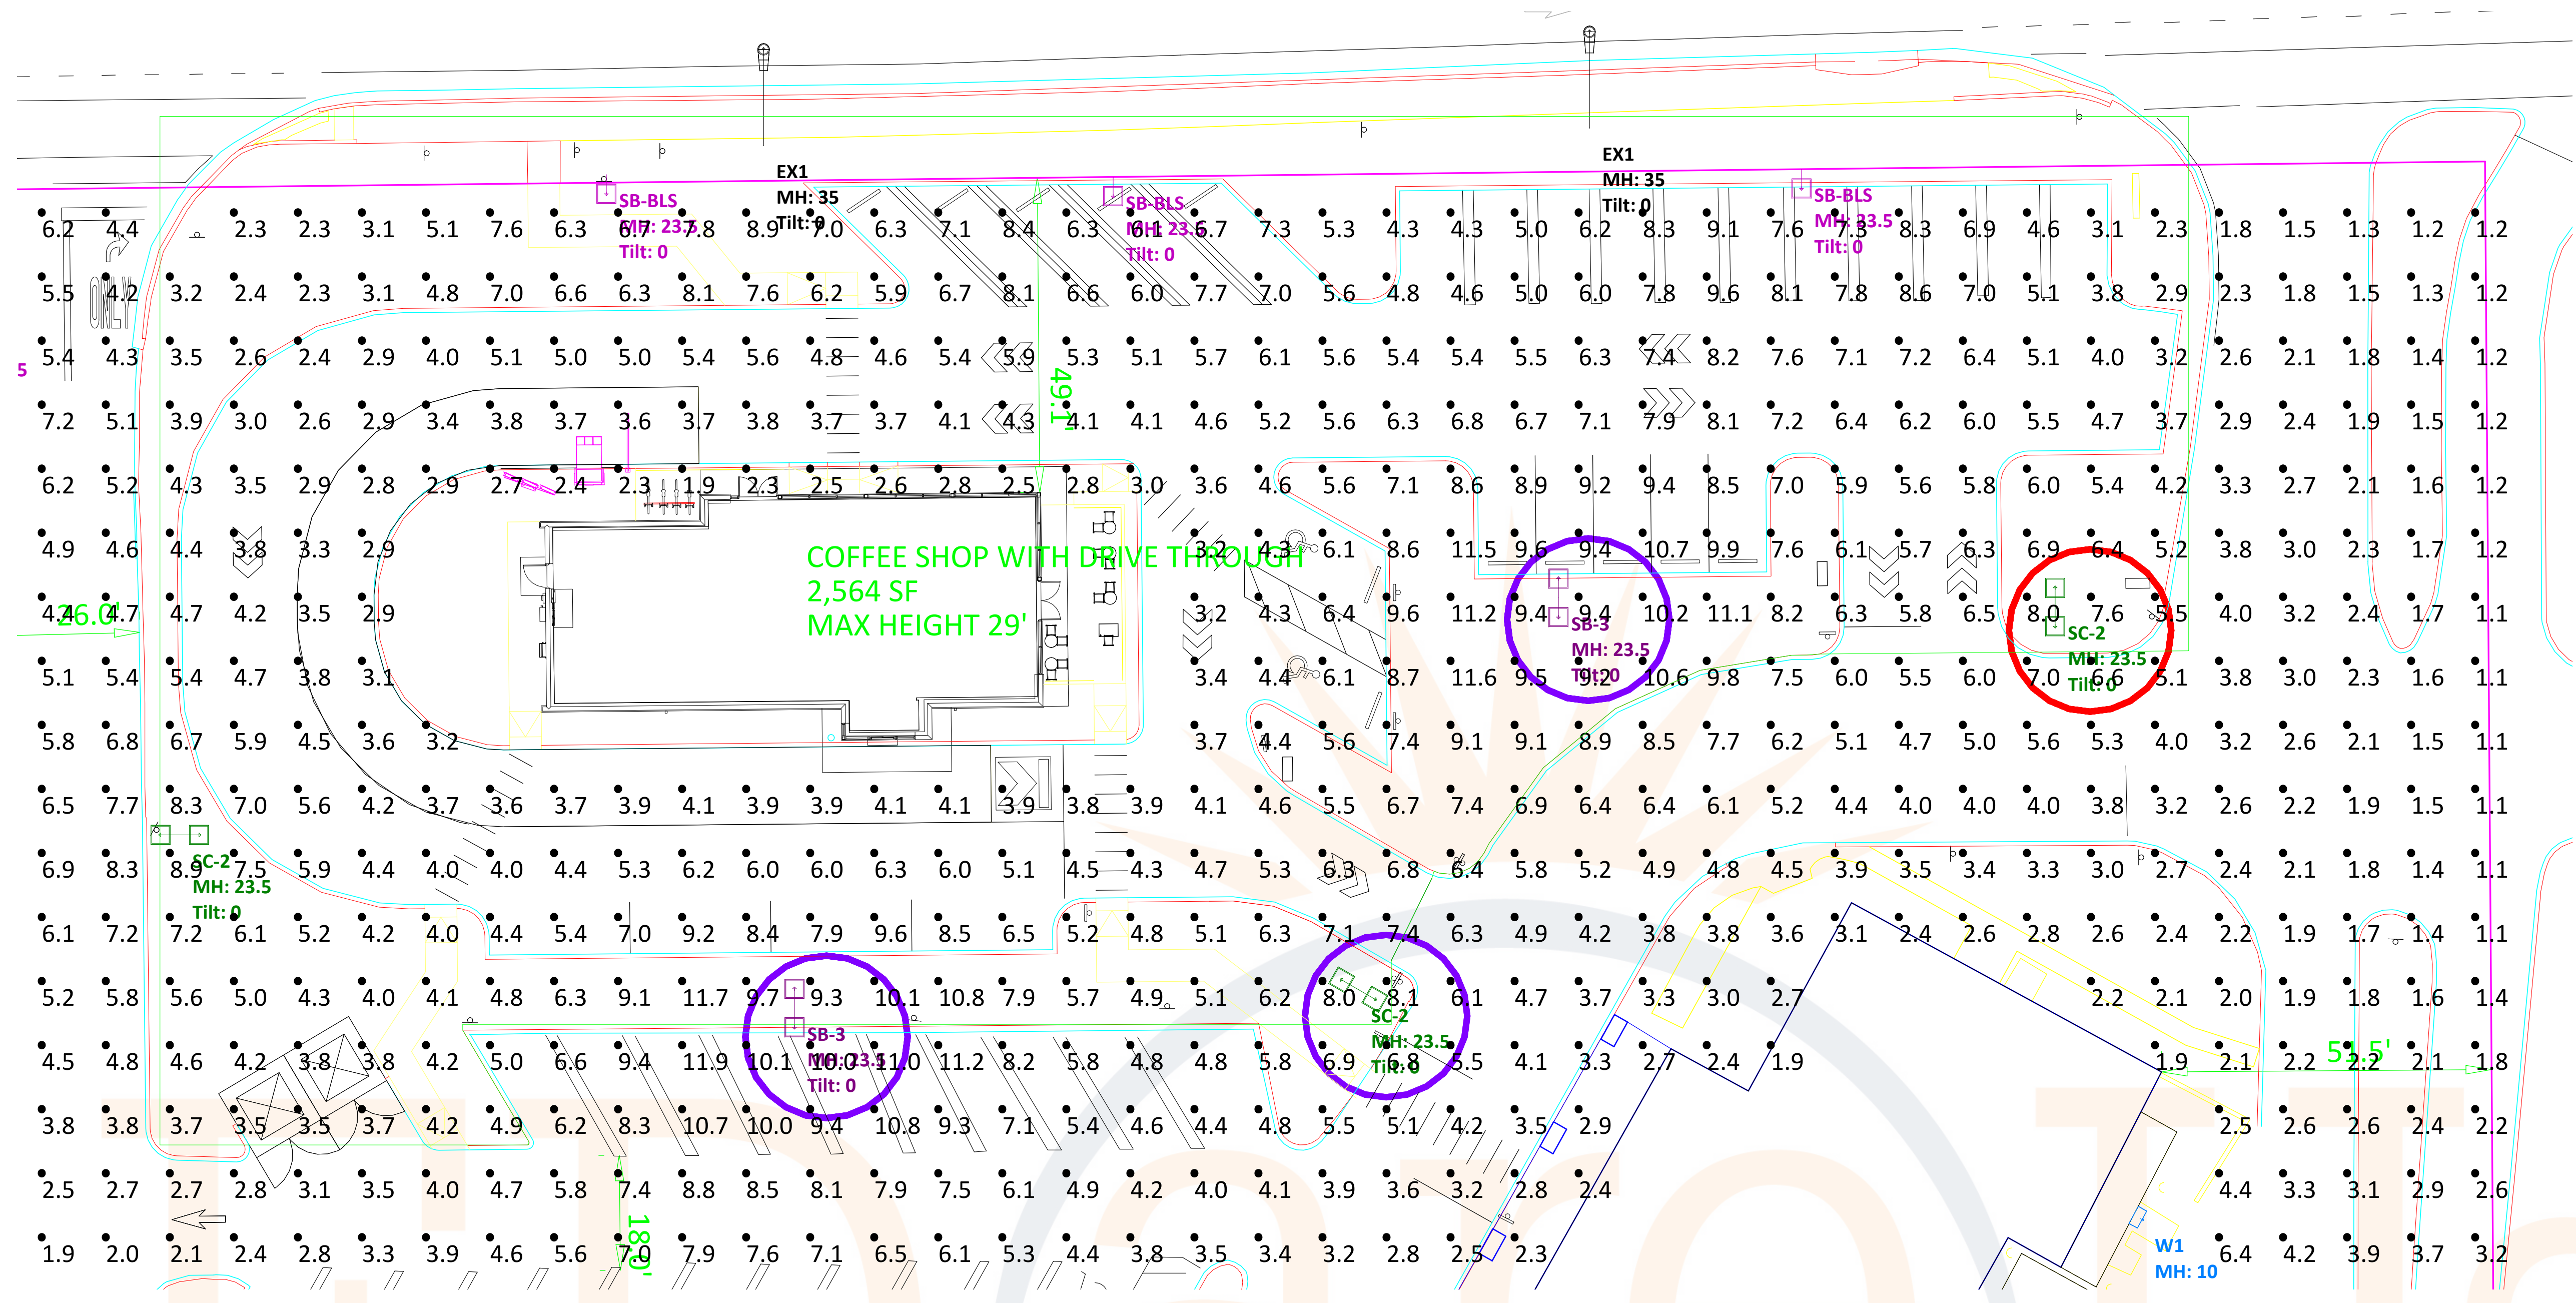

COFFEE SHOP WITH DRIVE THROUGH
2,564 SF
MAX HEIGHT 29'

Luminaire Schedule								
Symbol	Qty	Label	Arrangement	LLF	Description	Lum. Watts	Total Watts	Lum. Lumens
	1	SA-BS	SINGLE	0.950	LUMINOSO-SLS-160W-50K-T3M-BS	160.3	160.3	22658
	1	SB	SINGLE	0.950	LUMINOSO-SLS-160W-50K-T4M	159.7	159.7	25489
	3	SB-3	BACK-BACK	0.950	LUMINOSO-SLS-160W-50K-T4M	159.7	958.2	25489
	6	SB-BLS	SINGLE	0.950	LUMINOSO-SLS-160W-50K-T4M-BS	159.9	959.4	22245
	11	SC-2	BACK-BACK	0.950	LUMINOSO-SLS-160W-50K-T5M	160.4	3528.8	25154
	1	SC-3	3 @ 120 DEGREES	0.950	LUMINOSO-SLS-160W-50K-T5M	160.4	481.2	25154
	1	F1	SINGLE	0.950	LUMINOSO-FLM-200W-50K	199.6	199.6	23433
	19	W1	SINGLE	0.950	LUMINOSO-MWPK-45W-50K	44.02	836.38	5223
	15	W2	SINGLE	0.950	LUMINOSO-MWPK-135W-50K	132.19	1982.85	15655
	3	EX1	SINGLE	0.750	EXISTING 400W HPS STREET LIGHT	468	1404	36971
	2	EX2	SINGLE	0.750	EXISTING 150W HPS FLOOD LIGHT	188	376	9670
	5	EX3	SINGLE	0.950	EXISTING 110W LED AREA LIGHT	108	540	12069
	6	EX4	BACK-BACK	0.950	EXISTING 110W LED AREA LIGHT	108	1296	12057

Calculation Summary							
Label	Calculation Type	Units	Avg	Max	Min	Avg/Min	Max/Min
Starbucks	Illuminance	Fc	5.74	11.7	1.9	3.02	6.16

Notes	
1. NEW POLE AND FIXTURES ADDED TO MEET CODE.	
2. NEW FIXTURES (FLOOD / WALLPACK) ADDED ON BUILDING TO MEET CODE.	
3. NEW FIXTURES ADDED ON EXISTING POLE TO MEET CODE.	
3. FIXTURE REMOVED ON EXISTING POLE TO MEET CODE.	

9840 NW 77TH AVE
HIALEAH, FL 33016
(305) 823-2803
INFO@LEDAREUS.COM

SEAL:

REVISIONS	
02	RELOCATE NEW POLE 11/02/2020
03	REDUCE TRIPLE 5M 11/04/2020
04	NEW CAD LAYOUT 12/21/2020
05	ADJUST LOCATIONS 01/08/2021
06	NEW CAD 03/22/2021

PROJECT INFO:

BED BATH & BEYOND PLAZA
14824 S MILITARY TRAIL
DELRAY BEACH, FL 33484

PHOTOMETRIC PLAN

PROJECT INFO:

SHEET TITLE:

SALESPERSON: SOPHIE

DRAWN BY: WJJ

SCALE: 1" = 15'

DATE: 3/22/2021

SHEET

PH-1